




Luminaire Schedule		Arrangement	Description	Lum. Watts
Symbol	Qty	Label		
+	3	SA	SPAULDING CL1-X-90L-1-5K-4-BC FIBERGLASS POLE MTD. - 25' A.G.	215
+	2	SB	SPAULDING CL1-X-90L-1-5K-4-BC BUILDING MTD. - 25' A.G.	215

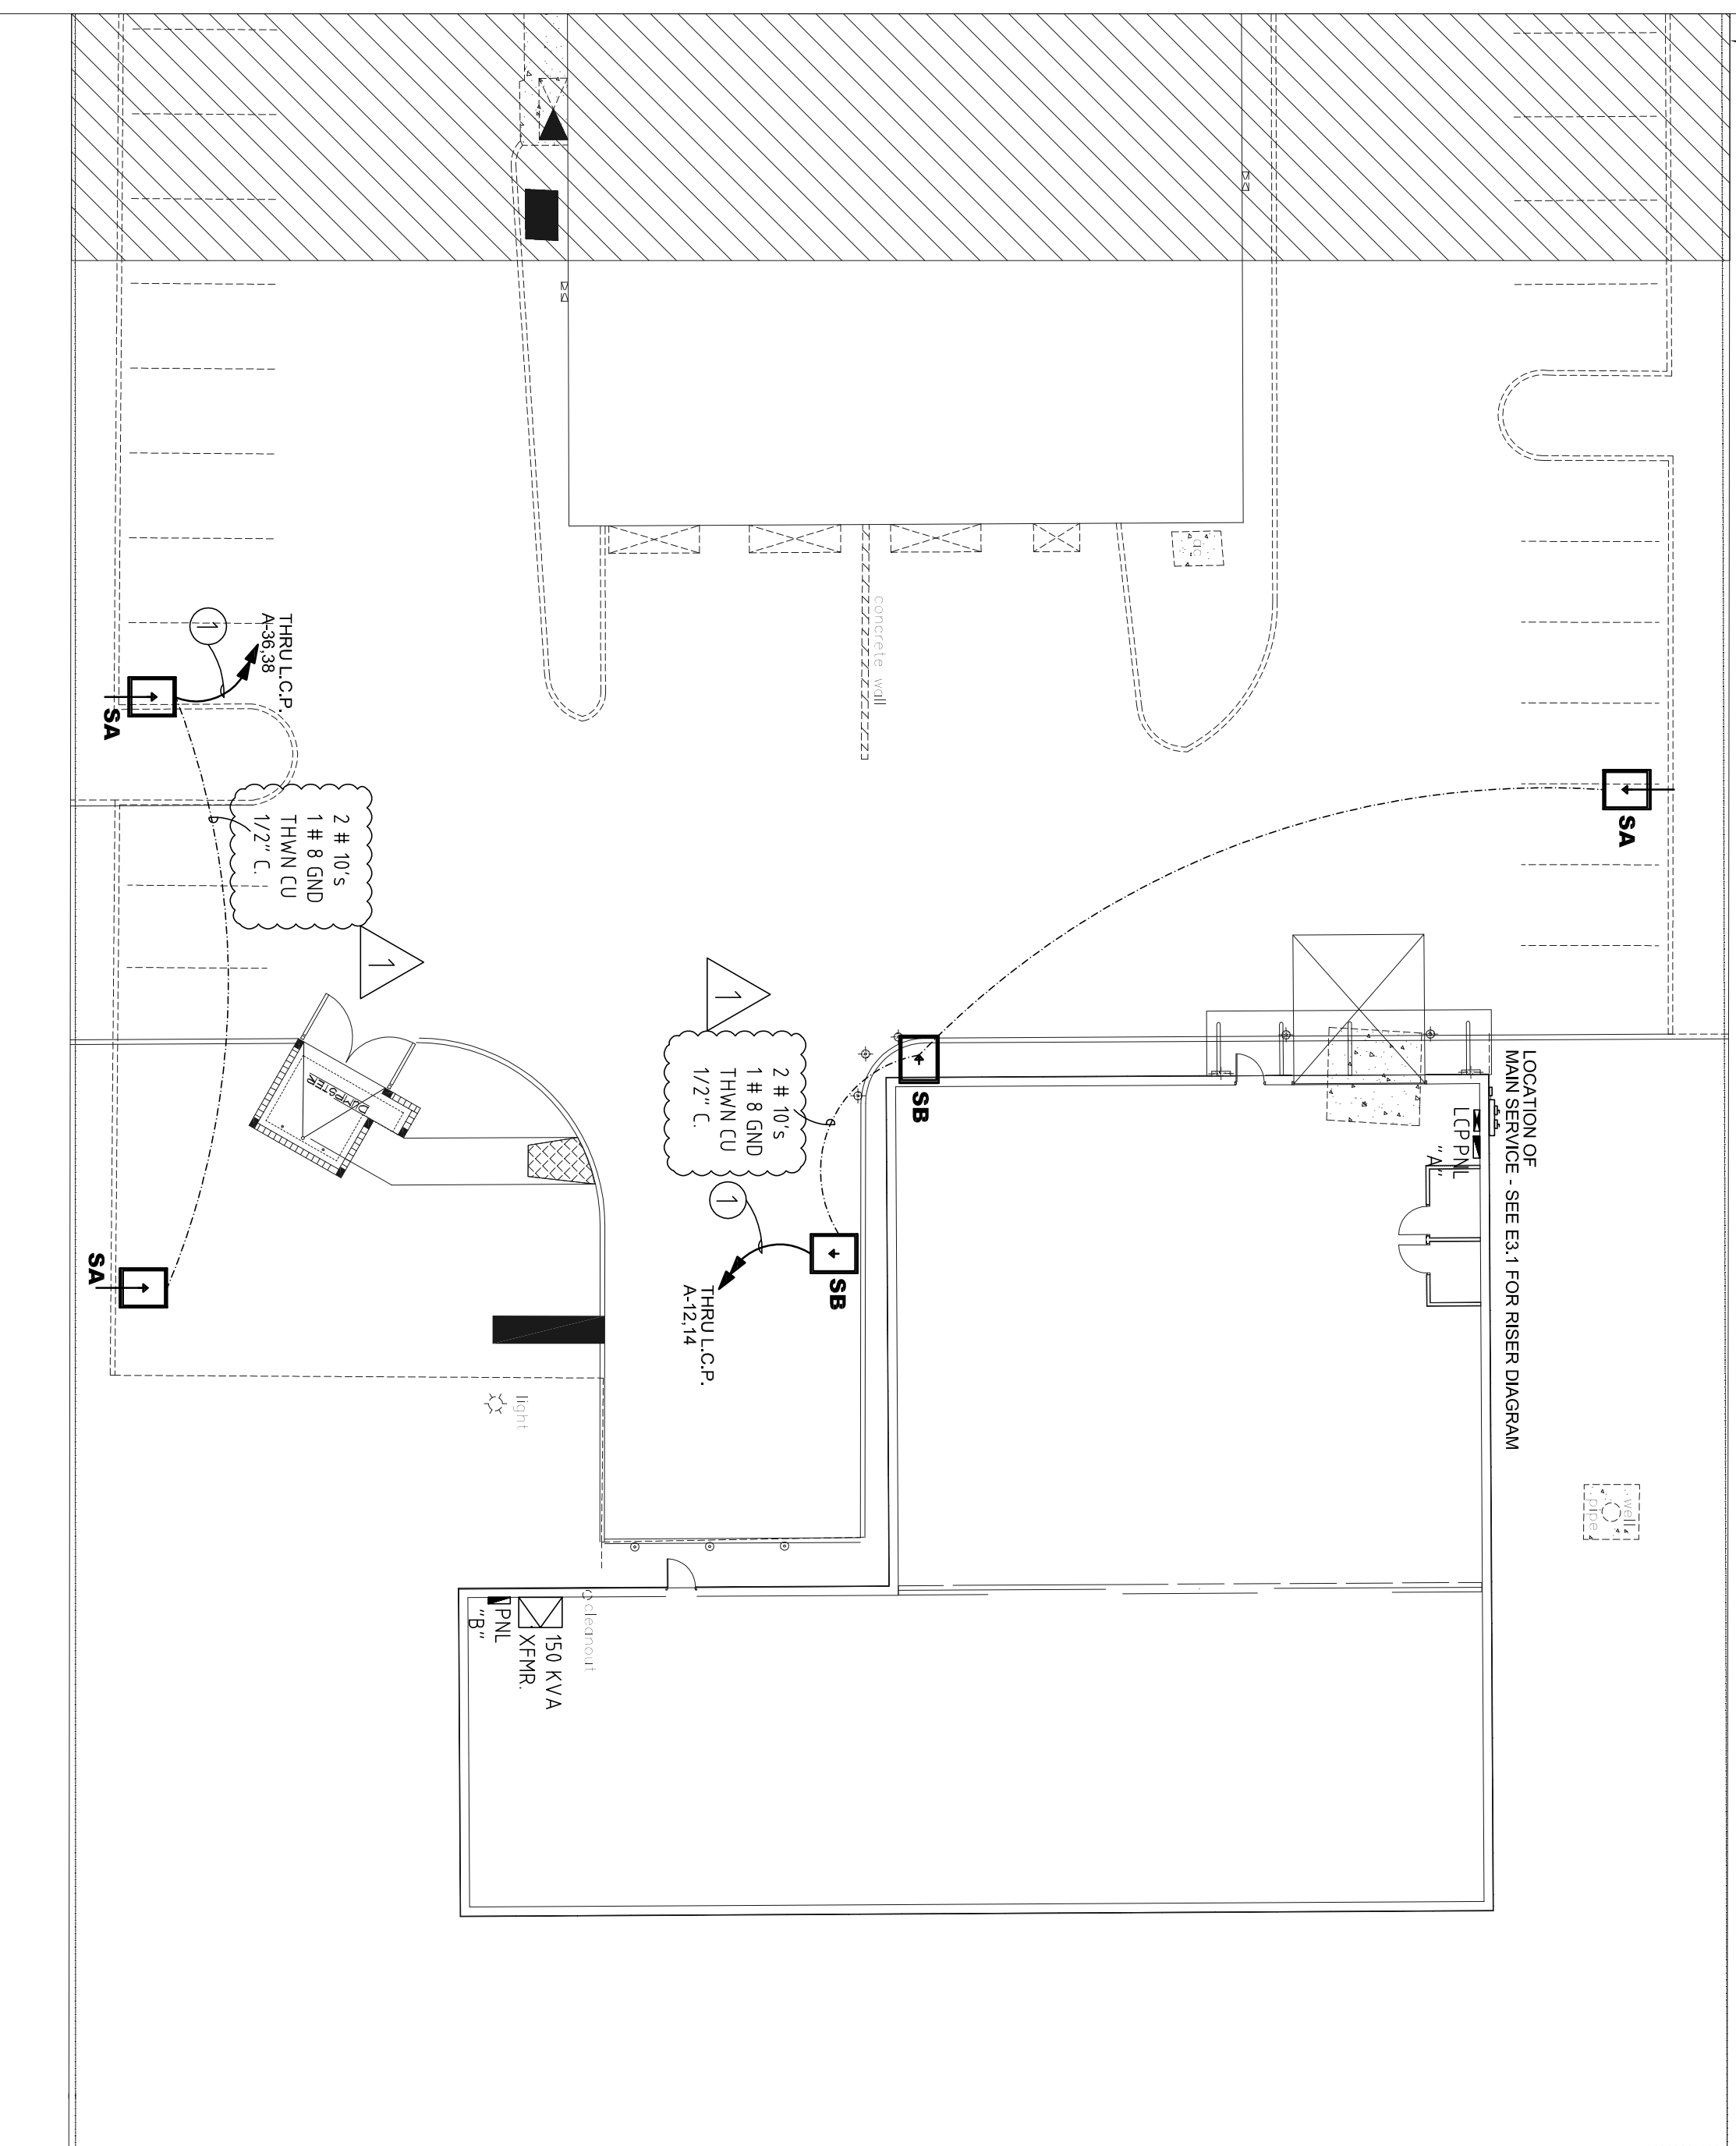

SITE LIGHTING PLAN
Scale: 1/16" = 1'-0"

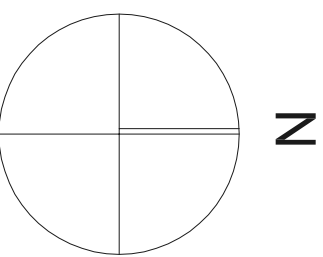

KEY NOTE:
① WIRE CIRCUIT THRU LIGHTING CONTROL PANEL PER FLORIDA BUILDING CODE 2010 - ENERGY CONSERVATION SECTION 505.2.2

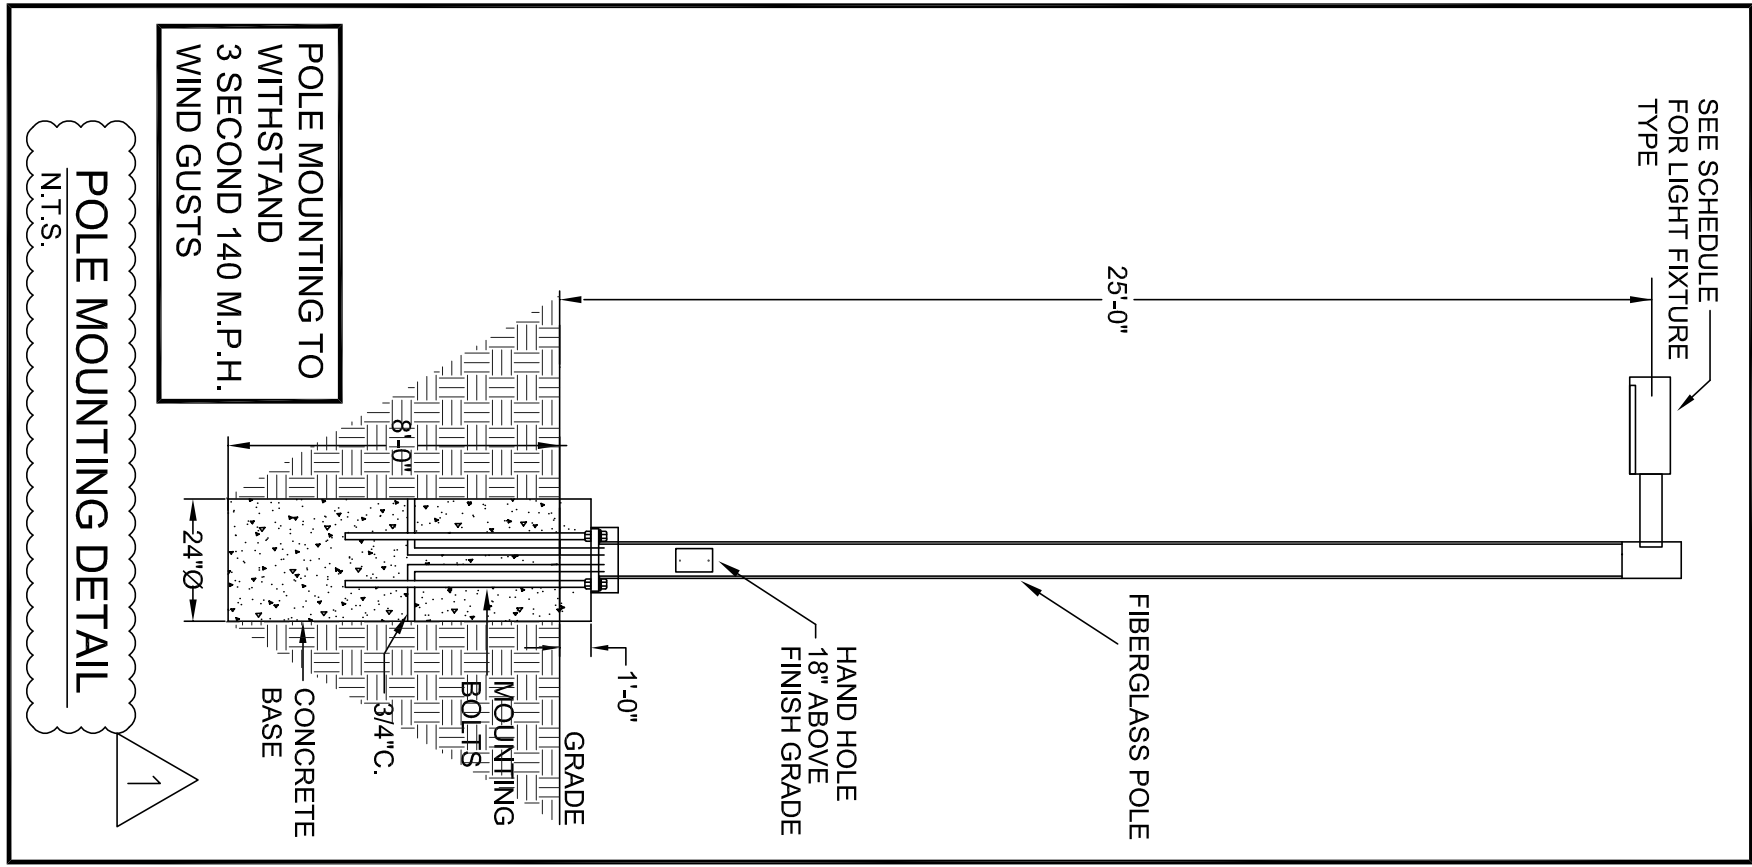

REVISION:	02/19/16
PERMIT SET:	04/20/15

FORMICA ASSOCIATES, Inc.
Consulting Engineers
3900 N.W. Boca Raton Blvd.
Suite #711
Boca Raton, FL 33431
Tel: (561) 368-3611 Fax: (561) 368-4733
Robert F. Formica, P.E. License #19733
Email: bob@formicaengineers.com

CONTRACTOR SHALL VERIFY ALL DIMENSIONS AND CONDITIONS OF EXISTING CONDITIONS ON THE WORK.

TO THE BEST OF MY KNOWLEDGE, THE PLANS AND SPECIFICATIONS COMPLY WITH THE APPLICABLE REGULATORY AGENCIES AS DETERMINED BY THE LOCAL AUTHORITY IN ACCORDANCE WITH THIS SECTION AND ALL FLORIDA STATUTES.

Architectural Seal

<p>DOMINICK SCARFO ARCHITECT 1620 N.W. 111th AVENUE CORAL SPRINGS, FLORIDA 33071 954-752-6451 VOICE & FAX dscarfoarcht@aol.com</p>	<p>PROJECT: STS INKS PROPOSED WAREHOUSE 8300 CONGRESS AVENUE BOCA RATON, FLORIDA</p>	<table border="1"> <tr> <th>No.</th> <th>REVISIONS</th> <th>DATE</th> </tr> <tr> <td>1</td> <td>ELECTRICAL B.D.C.</td> <td>5-15-15</td> </tr> <tr> <td>2</td> <td>MECHANICAL REVISION</td> <td>5-19-15</td> </tr> <tr> <td>3</td> <td>PLUMBING B.D.C.</td> <td>5-26-15</td> </tr> <tr> <td>4</td> <td>MEP-F/A REVISION</td> <td>6-29-15</td> </tr> <tr> <td>5</td> <td>PLUMBING RFI</td> <td>2-19-16</td> </tr> </table>	No.	REVISIONS	DATE	1	ELECTRICAL B.D.C.	5-15-15	2	MECHANICAL REVISION	5-19-15	3	PLUMBING B.D.C.	5-26-15	4	MEP-F/A REVISION	6-29-15	5	PLUMBING RFI	2-19-16
	No.	REVISIONS	DATE																	
1	ELECTRICAL B.D.C.	5-15-15																		
2	MECHANICAL REVISION	5-19-15																		
3	PLUMBING B.D.C.	5-26-15																		
4	MEP-F/A REVISION	6-29-15																		
5	PLUMBING RFI	2-19-16																		
<p>DRAWING NUMBER: SL1.1</p> <p>SHEET 1 OF 2</p>	<p>DRAWING TITLE: 1st FLOOR PLAN</p>	<p>PROJECT NUMBER: 215024 DATE: 04/20/15 SCALE: AS NOTED CHECKED: RFF APPROVED: RFF DRAWN: -</p>																		