


ELECTRICAL OUTLET MOUNTING DIAGRAM, TYP
SCALE: N.T.S.

LEGEND

SYMBOL	DESCRIPTION
⊕	DUPLEX RECEPTACLE
⊕⊕	DOUBLE DUPLEX RECEPTACLE
△	DATA OUTLET
▲	TELEPHONE OUTLET
▲	VOICE / DATA OUTLET
◆	TELEVISION OUTLET

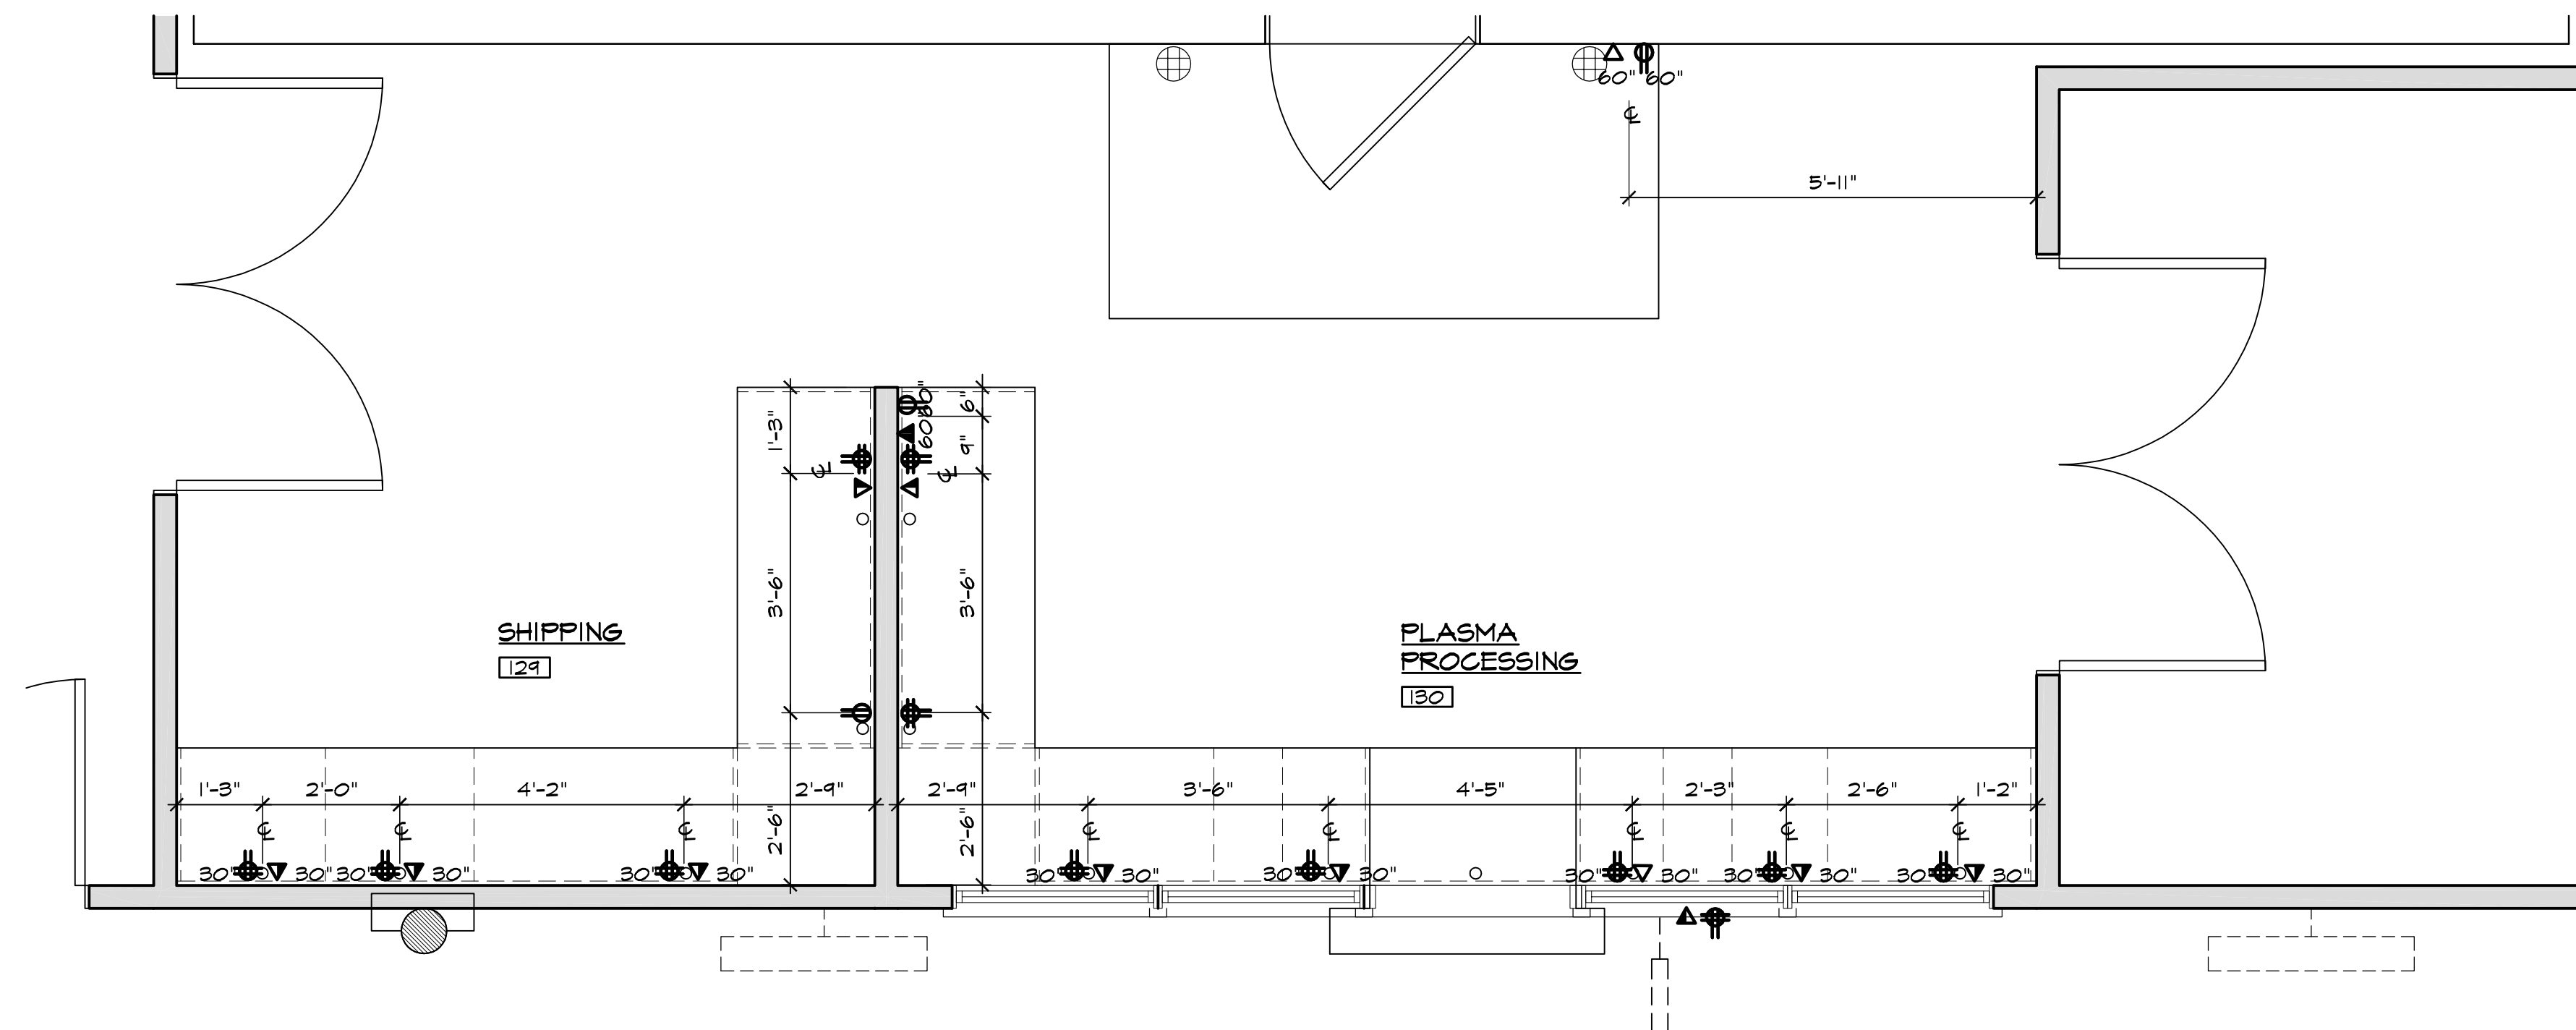


ELECTRICAL PLAN BLOW-UP
SCALE: 1/2"=1'-0"

NOTE: CONTRACTOR TO REFER TO ELECTRICAL POWER AND SIGNAL PLANS FOR COORDINATION

NOTE: ALL GROMMETS TO BE CENTERED WITH RECEPTACLES. VERIFY NUMBER AND LOCATION WITH TENANT.

NOTE: CONTRACTOR TO VERIFY LOCATIONS AND HEIGHTS w/ ELECTRICAL DRAWINGS AND NOTIFY ARCHITECT OF ANY DISCREPANCIES.

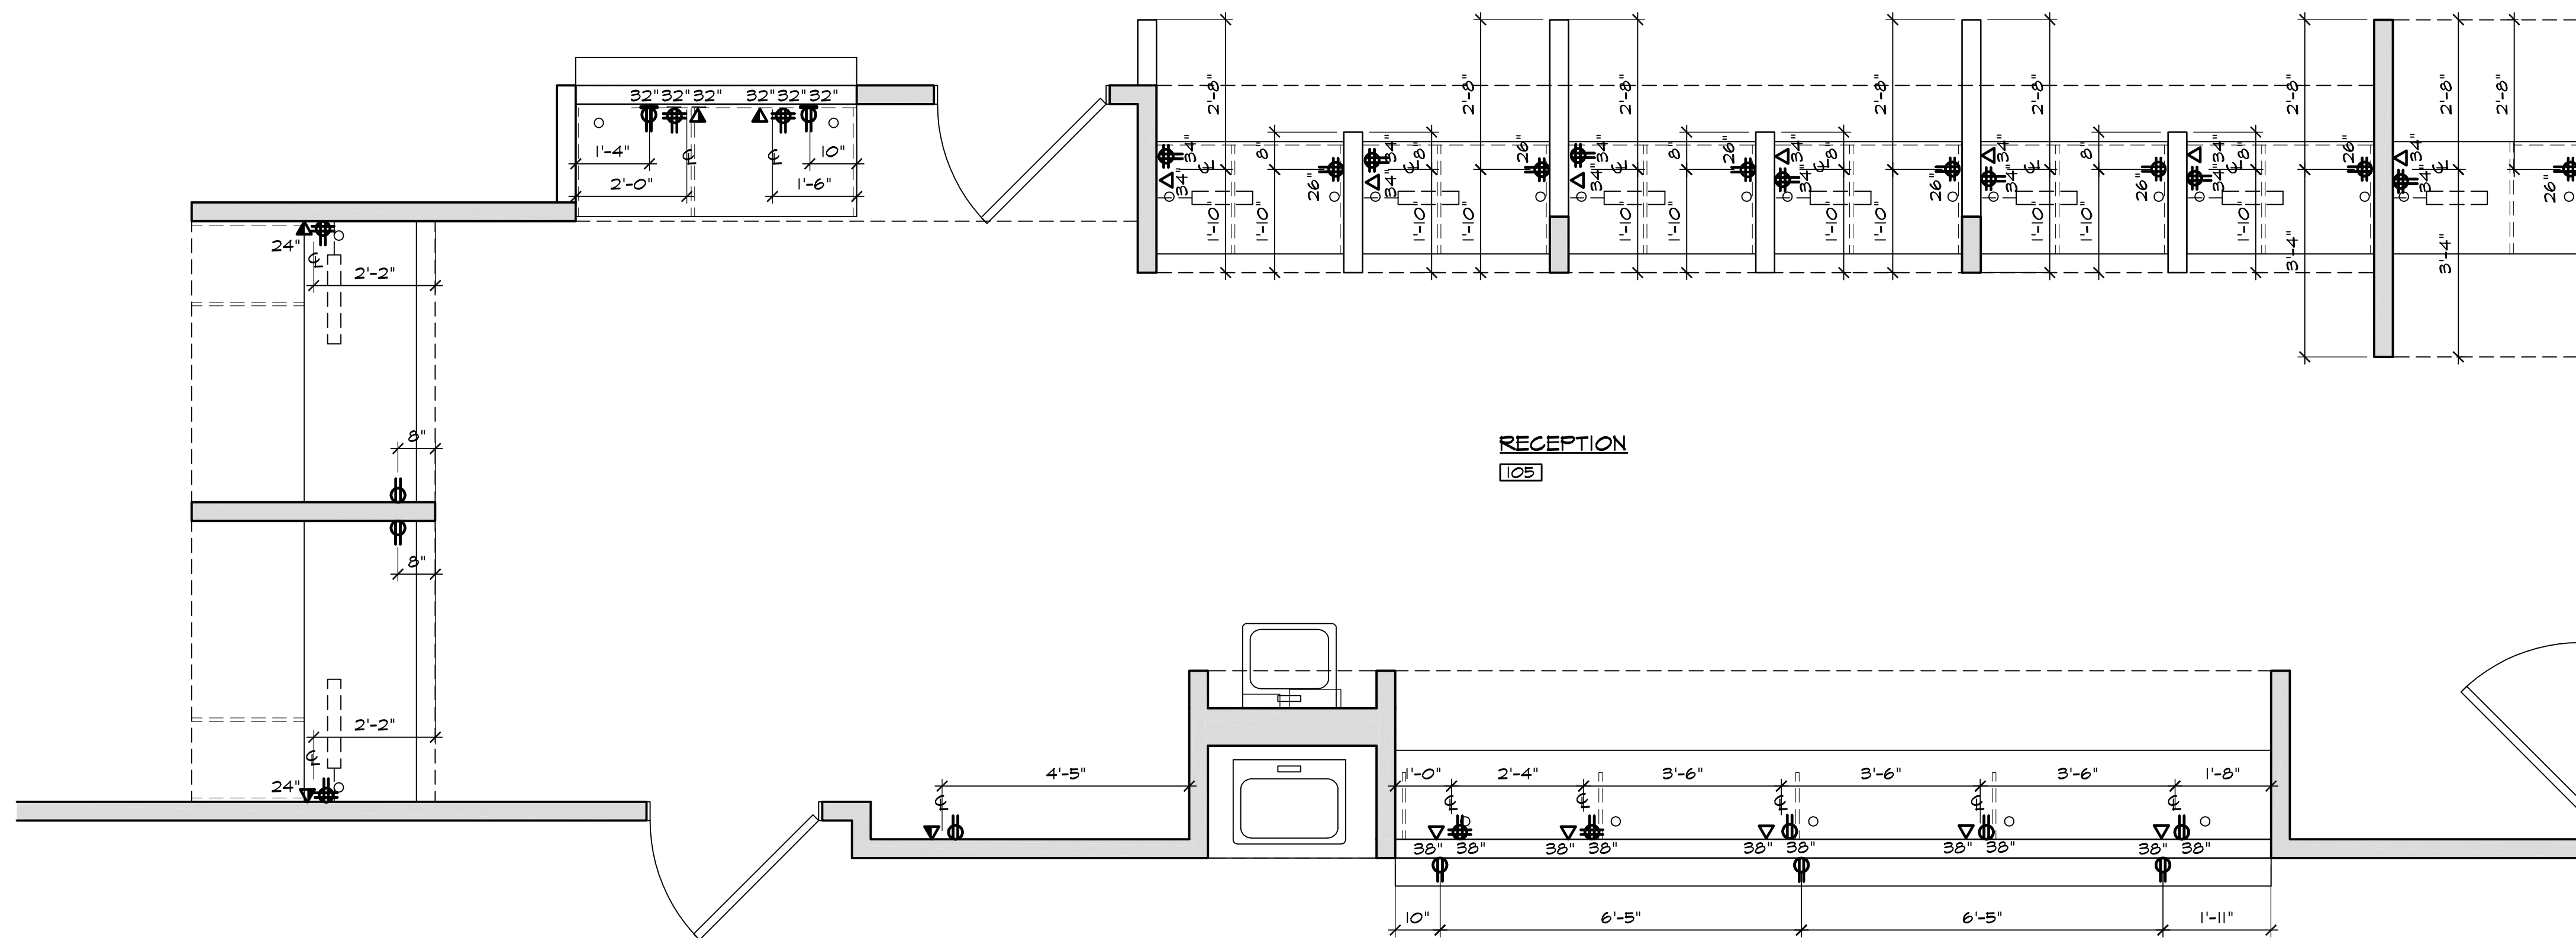


16 ELECTRICAL PLAN BLOW-UP
SCALE: 1/2"=1'-0"

NOTE: CONTRACTOR TO REFER TO ELECTRICAL POWER AND SIGNAL PLANS FOR COORDINATION

NOTE: ALL GROMMETS TO BE CENTERED WITH RECEPTACLES. VERIFY NUMBER AND LOCATION WITH TENANT.

NOTE: CONTRACTOR TO VERIFY LOCATIONS AND HEIGHTS w/ ELECTRICAL DRAWINGS AND NOTIFY ARCHITECT OF ANY DISCREPANCIES.

INTERIOR TENANT IMPROVEMENT FOR:
IMMUNOTEK BIO CENTERS, LLC
4560 LAKE WORTH ROAD
OFFICE DEPOT PLAZA, SUITE B-5
LAKE WORTH, PALM BEACH COUNTY, FL 33463

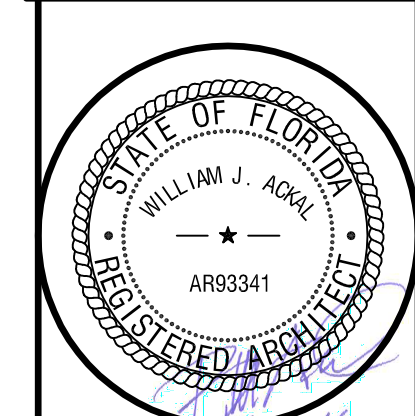

COPYRIGHT © 2016 ACKAL ARCHITECTS, APC.
THIS DOCUMENT IS THE PROPERTY OF
ACKAL ARCHITECTS, APC.
THIS DOCUMENT MAY NOT BE COPIED,
REPRODUCED OR USED WITHOUT
WRITTEN CONSENT FROM
ACKAL ARCHITECTS, APC.

proj. no. 16-002
date: 08-02-2016
project architect: BA
drawn by: A.D., J.L., C.T.
file name: LAKEWORTH
revised:
plot scale: 1:1
sheet name:
ELECTRICAL
BLOW-UP PLANS

sheet no.
A9.5
16 of 42