

1. CONNECT ALL DOWNSPOUTS TO UNDERGROUND STORM WATER SYSTEM. PROVIDE "SQUARE TO ROUND" CONNECTION BOOT.

- 01 0.040" PRE-FINISHED ALUMINUM GUTTER. SEE DETAILS FOR MORE INFORMATION.
- 02 NOT USED
- 03 PRE-ENGINEERED CANOPY SYSTEM. SEE DETAILS FOR MORE INFORMATION.
- 04 NOT USED
- 05 3"x8" PRE-ENGINEERED ALUMINUM STRUCTURAL SUPPORT BRACE ASSEMBLY, PRIME & PAINT. SEE DETAIL 6/A3.11 AND STRUCTURAL DRAWINGS FOR MORE INFORMATION. TYPICAL
- 06 THRU WALL ROOF SCUPPER & 6"x6" 0.040" PRE-FINISHED ALUMINUM DOWNSPOUT
- 07 6"Ø OVERFLOW DRAIN
- 08 4"x4" 0.040" PRE-FINISHED ALUMINUM DOWNSPOUT
- 09 PRE-ENGINEERED "BOXED AWNING LOUVER", TYPICAL
- 10 EXPOSED BAR-JOISTS AND DECK ABOVE (SEE STRUCTURAL DRAWINGS), CEILINGS, LIGHTING, ETC. TO BE PROVIDED UNDER SEPARATE PERMIT AS PART OF TENANT IMPROVEMENT DOCUMENTS, TYPICAL
- 11 EXPOSED STEEL BEAMS AND DECK ABOVE (SEE STRUCTURAL DRAWINGS)
- 12 RECESSED DOWN LIGHT, TYPICAL. (SEE ELECTRICAL DRAWINGS)
- 13 SURFACE MOUNTED WALL SCONCES, ONE POINTED UP AND ONE POINTED DOWN. SEE ELEVATIONS AND SECTIONS, TYPICAL. (SEE ELECTRICAL DRAWINGS)
- 14 SURFACE MOUNTED WALL SCONCES. SEE ELEVATIONS AND SECTIONS, TYPICAL. (SEE ELECTRICAL DRAWINGS)

GENERAL NOTES


KEY NOTES XX REFERENCED BY THIS SYMBOL

NOT USED SCALE NA 5

NOT USED SCALE NA 4

NOT USED SCALE NA 3

NOT USED SCALE NA 2

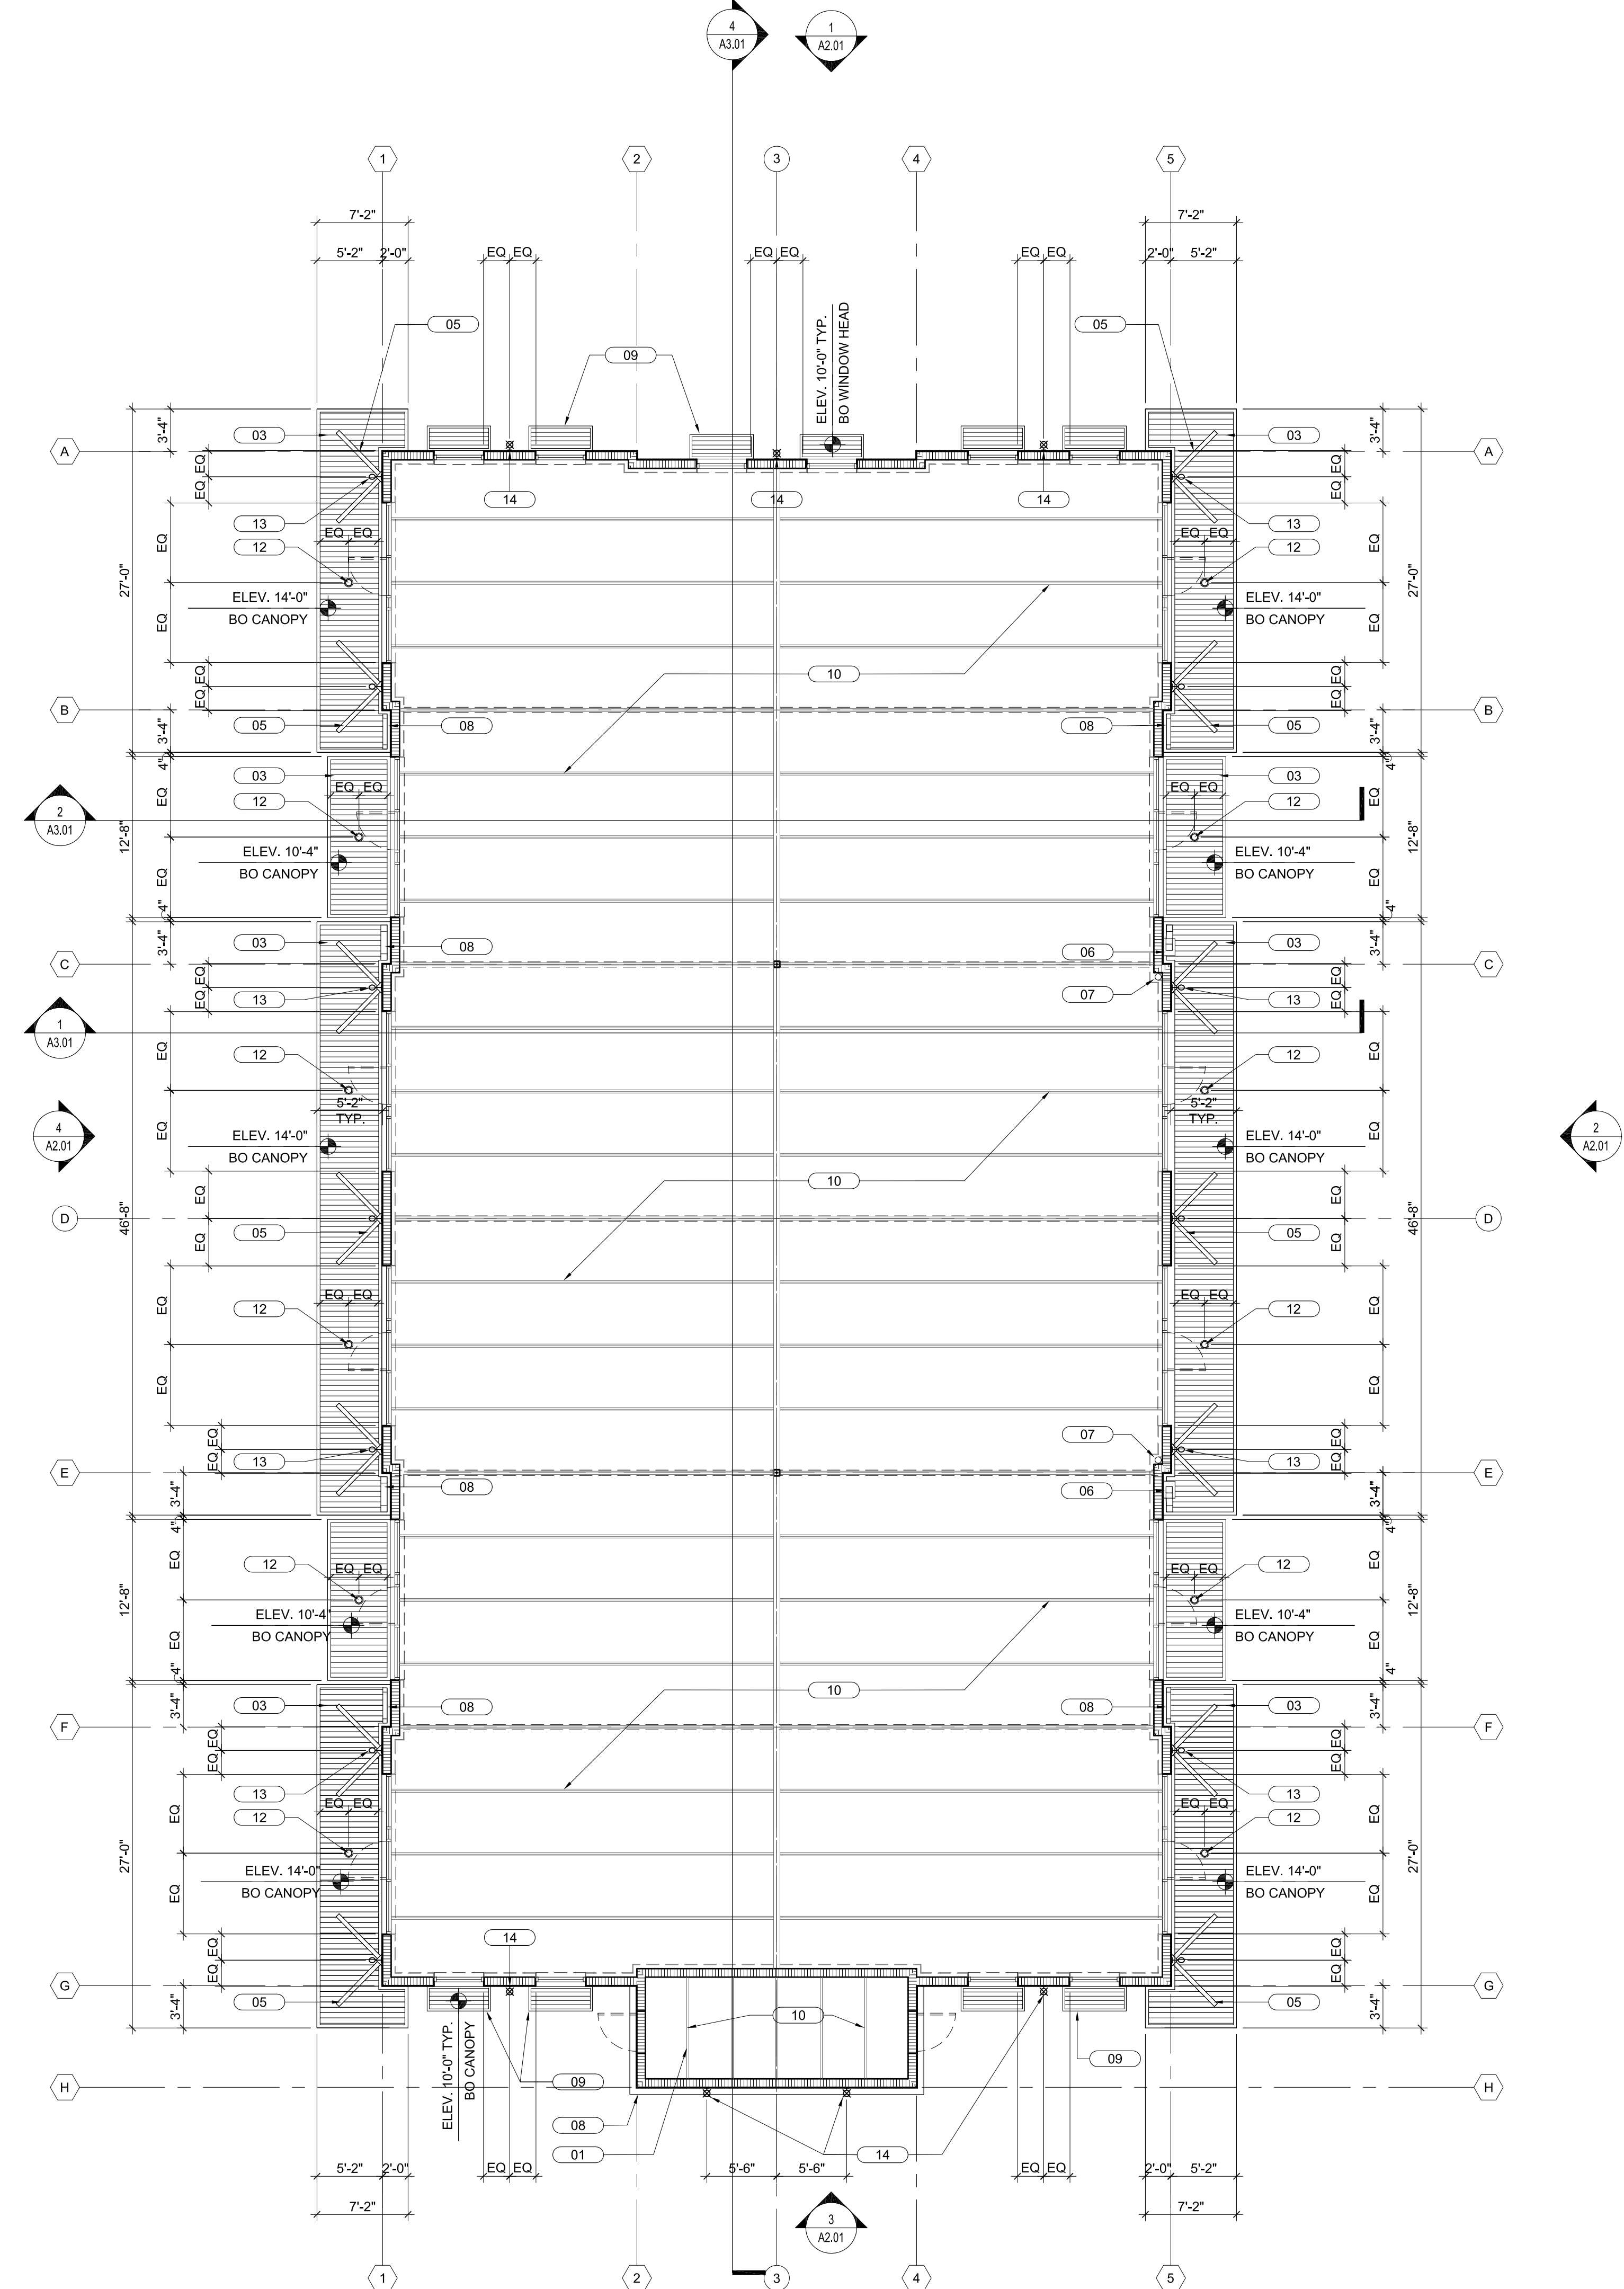

REFLECTED CEILING PLAN PLAN SCALE 1/8" = 1'-0" 1

○	
○	
○	
○	
○	
○	
○	
○	

BULLETIN LOG



WESTLAKE AUXILIARY SALES CENTER
 CITY OF WESTLAKE
 PALM BEACH COUNTY, FLORIDA

ISSUE DATE: - 09-30-16
 ISSUED FOR:
 PERMIT - BUILDING SHELL ONLY
 © AS DATED ARCHITECTURE PLUS INTERNATIONAL, INC.

△	
△	
△	
△	
△	
△	
△	

REVISION LOG

STATE REGISTRATIONS	
FL #AAC001935	NC #8581
SC #6109	GA #10079
TN #00102675	

Juan F. Romero AIA License No. AR000793
TO THE BEST OF THE KNOWLEDGE OF THE ARCHITECT AND ENGINEER, SAID PLAN AND SPECIFICATIONS COMPLY WITH THE APPLICABLE MINIMUM BUILDING CODES AND THE APPLICABLE MINIMUM SAFETY STANDARDS.

WESTLAKE AUXILIARY SALES CENTER
 PROJECT NAME
REFLECTED CEILING PLAN
 SHEET NAME
 PROJECT NUMBER: **2016.082**
 DRAWN BY: **PC** CHECKED BY: **PC**
 SCALE: **AS NOTED**
A1.11
 SHEET NUMBER