

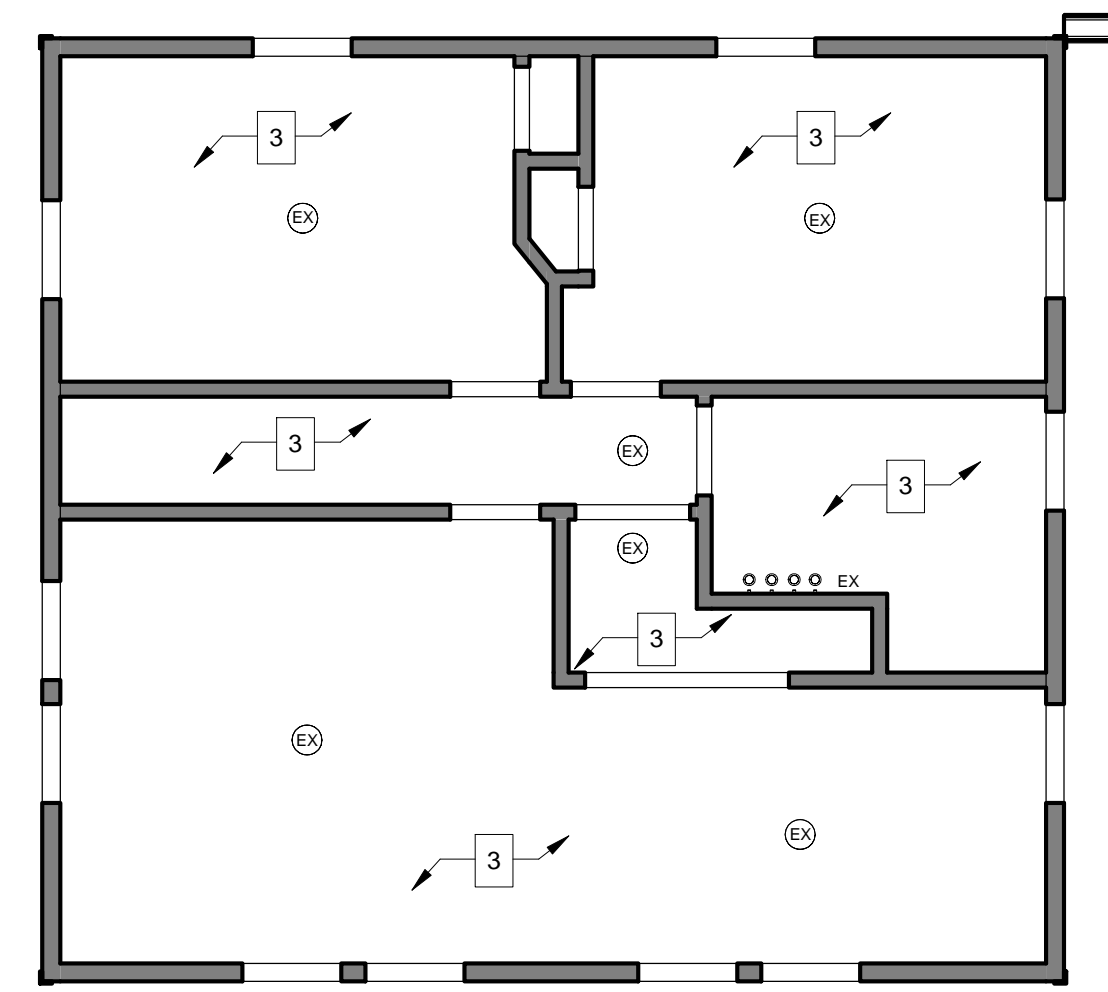


©2016 AW ARCHITECTS, INCORPORATED ALL RIGHTS RESERVED. NO PART OF THESE IDEAS, PLANS OR DESIGNS MAY BE REPRODUCED, COPIED OR UTILIZED GRAPHICALLY IN ANY FORM WHATSOEVER WITHOUT THE EXPRESSED WRITTEN CONSENT OF AW ARCHITECTS INCORPORATED AND ITS BOARD OF DIRECTORS.

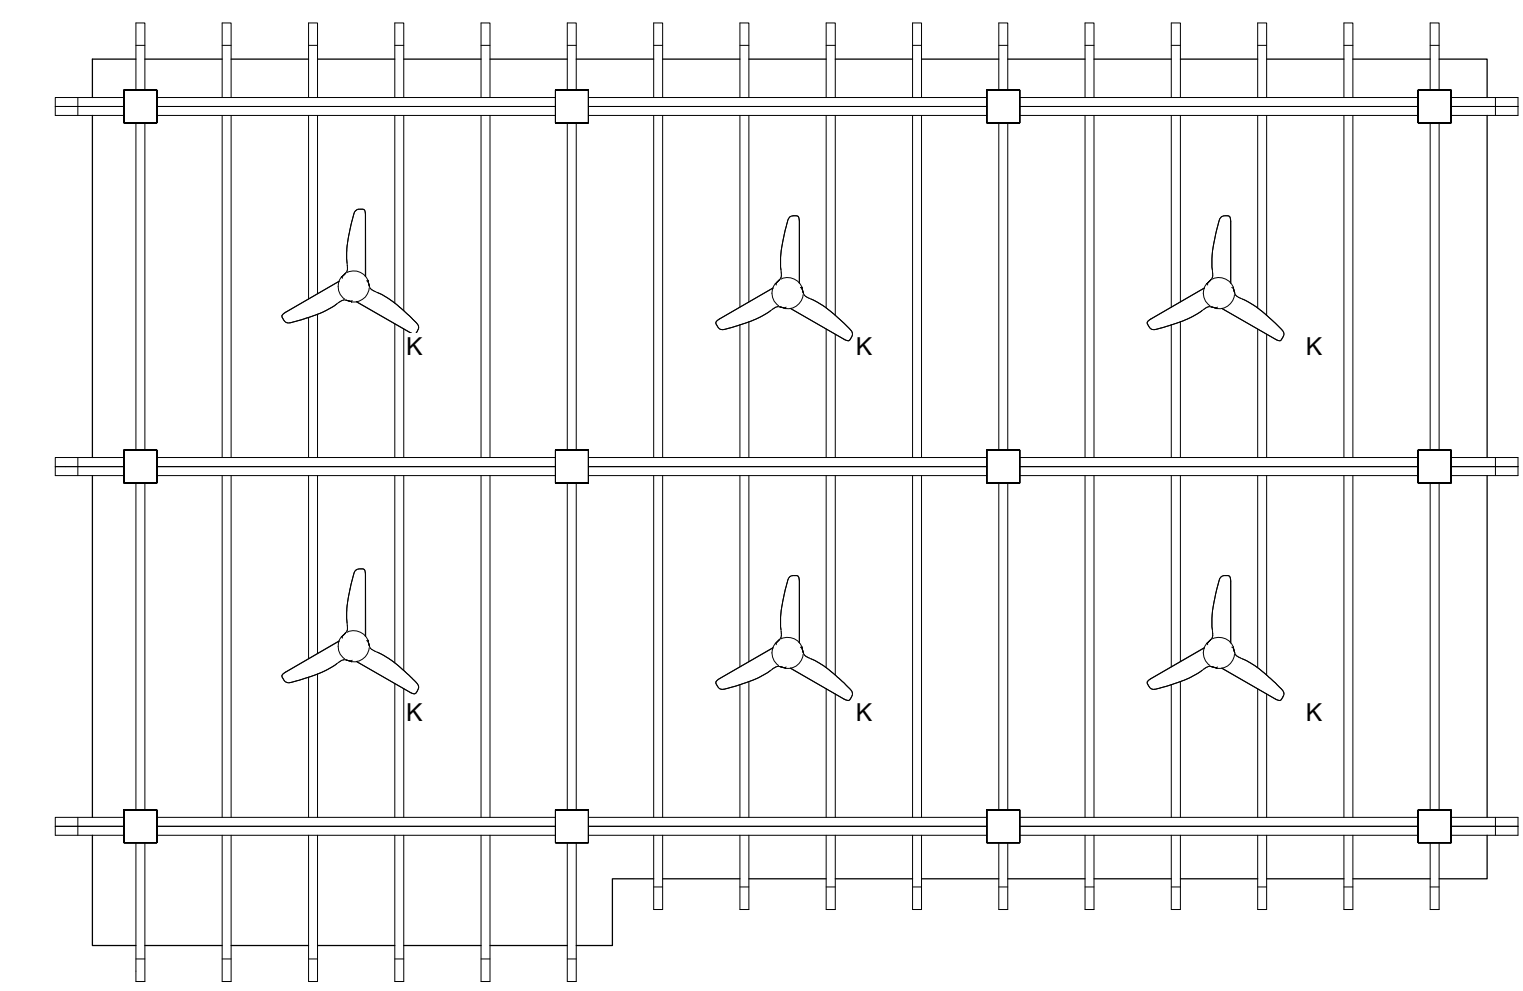

NOTES:
 1. REFER TO ELECTRICAL SHEETS FOR ADDITIONAL INFORMATION
 2. SECOND FLOOR LIGHTING TO REMAIN. REPLACE AS NECESSARY.
 3. 'EX' INDICATES EXISTING LIGHTING FIXTURE

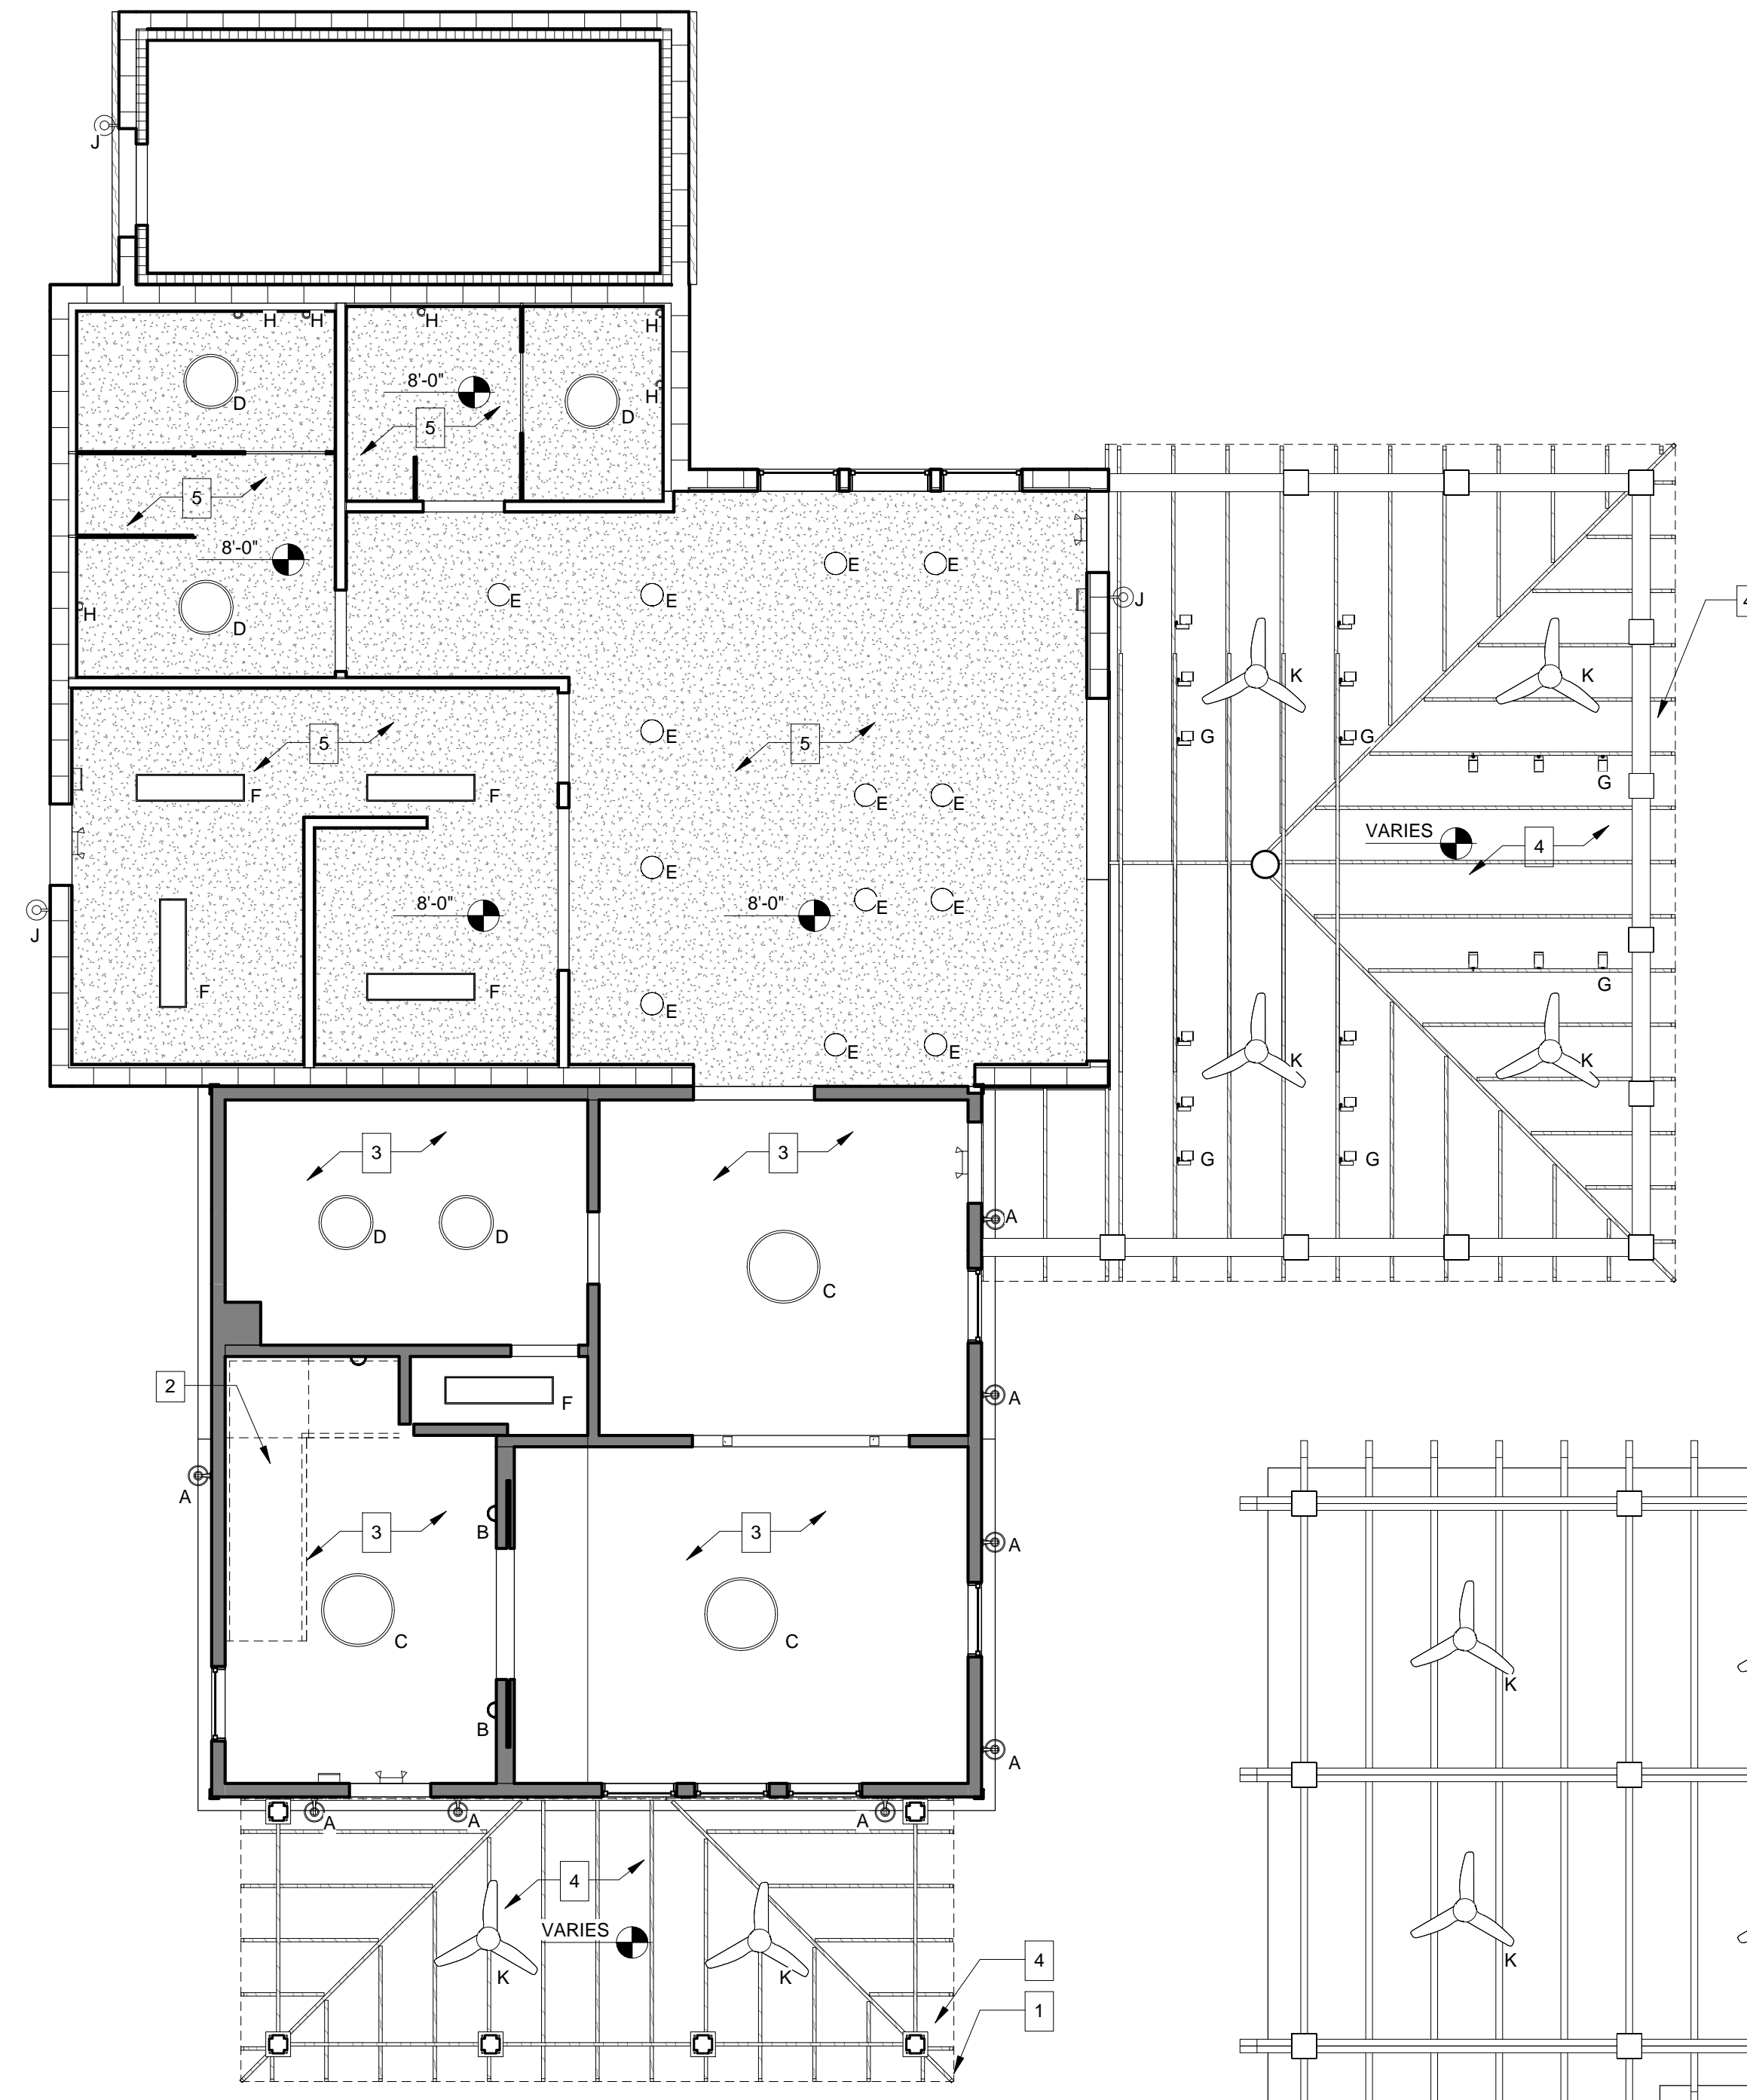

REFER TO ELECTRICAL SHEETS FOR ADDITIONAL INFORMATION

2 2ND FLOOR REFLECTED CEILING PLAN
SCALE: 3/16"=1'-0"

1 1ST FLOOR REFLECTED CEILING PLAN
SCALE: 3/16"=1'-0"

CEILING PLAN GENERAL NOTES		CEILING PLAN LEGEND		CEILING PLAN LEGEND CONTINUED	
1	ROOF LINE		SMALL BRIDGEWATER WALL MOUNT 6'-6" AFF TO BOTTOM		RESTROOM SCONCE
2	EXISTING STAIRS		WALL SCONCE LED 6'-6" AFF		WALL SCONCE
3	EXISTING WOOD CEILING TO REMAIN, PATCH AND REPAIR AS NECESSARY		18" SURFACE LED		CEILING FAN, HAIKU WITH LIGHT KIT
4	NEW 1X6 TONGUE AND GROVE WOOD CEILING IN BETWEEN RAFTERS		12" SURFACE LED		
5	NEW GYPSUM BOARD CEILING		RECESSED CAN LIGHT 5" LED		
			1X4' SEALED LENSE SURFACE LED		
			TRACK LIGHT LED		