


- FIRE ALARM NOTES:**
1. ALL FIRE ALARM COMPONENTS SHALL BE LISTED IN ACCORDANCE WITH NFPA 72, EDITION 2010, AND SHALL BE COMPATIBLE WITH THE FIRE ALARM SYSTEM.
 2. THE FIRE ALARM PANEL SHALL BE LOCATED IN THE BUILDING COMMON ELECTRICAL ROOM WHICH SHALL BE MECHANICALLY VENTILATED.
 3. FIRE ALARM MANUAL PULL STATIONS SHALL BE MOUNTED @ 48" AFF.
 4. ALL FIRE ALARM PULL STATIONS SHALL BE MOUNTED @ 48" AFF. REQUIRED WITH LISTED APPROVED FIRES TOP COMPOND, TO MATCH PENETRATED STRUCTURES FIRE RATING.
 5. FIRE ALARM WIRING SHALL NOT EXCEED 40% FILL OF CONDUIT.
 6. ALL FIRE STOP PENETRATIONS SHALL BE MADE WITH APPROVED INECO ELECTRICAL TUBING.
 7. ROUTING OF THE FIRE ALARM SYSTEM CONDUIT IS DIAGRAMMATIC. VERIFY EXACT LOCATIONS PRIOR TO STARTING WORK.
 8. ALL STROBE LIGHTS SHALL ACTIVATE UPON INITIATION OF THE GENERAL ALARM, AND SHALL BE SYNCHRONIZED IN OPEN AREAS.
 9. MOUNT FIRE ALARM SYSTEM HORN/STROBES AT 80" A.F.F. OR 6" BELOW CEILING WHICH EVER IS LOWER.
 10. THIS SYSTEM SHALL BE INSTALLED BY A UL CONTRACTOR CAPABLE OF PROVIDING A UL CERTIFICATE FOR THE PROPERTY.
 11. CONNECT NEW DEVICES FOR OPERATION AS REQUIRED.

CODE COMPLIANCE NOTE:
THE DESIGN AND INSTALLATION OF THE FIRE ALARM SYSTEM SHALL BE IN ACCORDANCE WITH NFPA 72, STATE AND LOCAL CODES AND ORDINANCES.

SYMBOL LEGEND:	
SYMBOL	DESCRIPTION
	PULL STATION
	SILENT KNIGHT - SP5-SA
	ELEGITD STROBE
	SYSTEM SENSOR HSC24115
	CANDELA AS INDICATED
	WET PIPE
	CANDELA AS INDICATED
	HORN/STROBE
	CANDELA AS INDICATED
	FIRE ALARM CONTROL PANEL
	SMOKE DETECTOR
	SYSTEM SENSOR 200 SERIES
	POWER LIMITED
	FLOW SWITCH (F.S.)
	WEATHER PROOF
	CEILING MOUNTED

- GENERAL NOTES:**
1. INSTALL DEVICES PER NEW E1009 PLANS. ADDITIONAL DEVICES W/STROBE REQUIRED BY FIRE MARSHALL AND THESE DEVICES TO FLOOR PLAN.
 2. WIRE ALL DEVICES BACK TO FIRE ALARM PANEL AND RUN SYSTEM TESTS.
 3. ANY MODIFICATIONS SHALL BE CERTIFIED AND APPROVED BY FIRE DEPARTMENT.

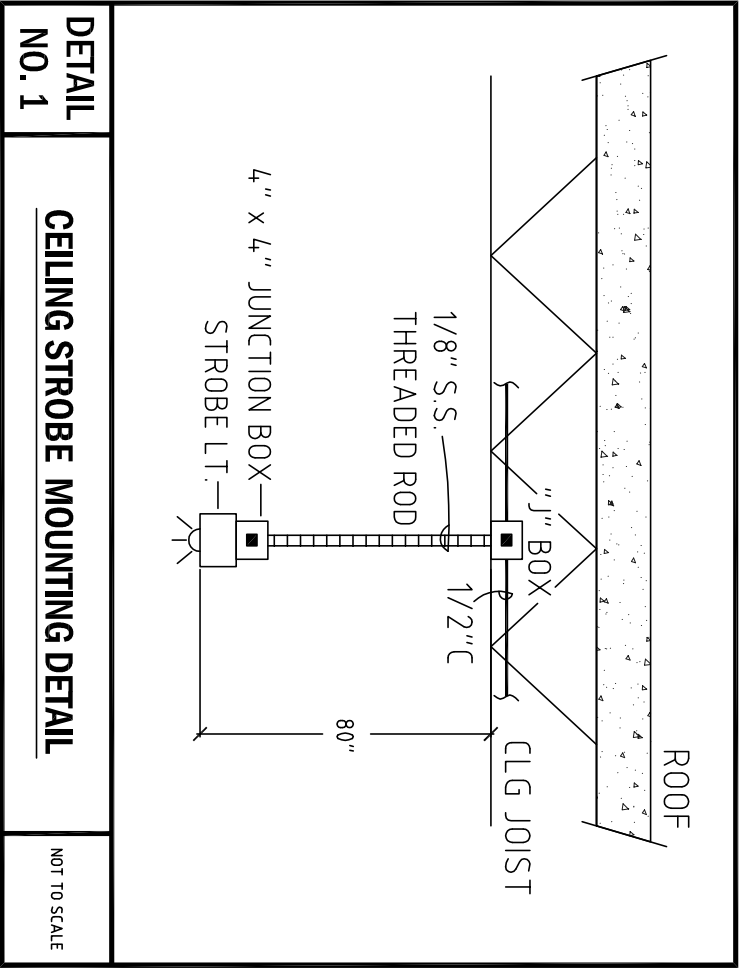

FIRE ALARM PLAN
Scale: 3/16" = 1'-0"

FORMICA & ASSOCIATES, Inc.
Consulting Engineers
3600 N.W. Boca Raton Blvd.
Suite #711
Boca Raton, FL 33431
TEL: (954) 366-5811 FAX: (954) 366-4733
Robert F. Formica, P.E., License #19731
Email: bob@formicaengineering.com

CONTRACTOR SHALL VERIFY ALL DIMENSIONS AND LOCATIONS OF ALL DEVICES PRIOR TO INSTALLATION OF THE SYSTEM.

PROJECT NUMBER 215024
DATE: 04/20/15
SCALE: AS NOTED
CHECKED: RFF
APPROVED: RFF
DRAWING: -
Architectural Seal

AR 10248

DOMINICK SCARFO ARCHITECT
1620 N.W. 111th AVENUE
CORAL SPRINGS, FLORIDA 33071
954-752-6451 VOICE & FAX
dscarfoarcht@aol.com

PROJECT: STS INKS PROPOSED WAREHOUSE
8300 CONGRESS AVENUE
BOCA RATON, FLORIDA
DRAWING TITLE: 1st FLOOR PLAN

No.	REVISIONS	DATE
1	ELECTRICAL B.D.C.	5-15-15
2	MECHANICAL REVISION	5-19-15
3	PLUMBING B.D.C.	5-26-15
4	MEP-F/A REVISION	6-29-15