



- MECHANICAL DRAWING KEYNOTES**
- 4" SHEET METAL BATHROOM EXHAUST DUCT THRU ROOF WITH INSECT SCREEN AND RAIN CAP.
 - 4" SHEET METAL DRYER EXHAUST DUCT THRU ROOF WITH RAIN CAP.
 - PROVIDE LOCKABLE BOX FOR T-STAT.
 - PROVIDE 24X24 GREENHECK GRAVITY RELIEF DAMPER MODEL WRH PENTHOUSE. MOUNT RELIEF DAMPER ON EXISTING CURB. MODIFIED EXISTING CURB AS REQUIRED.

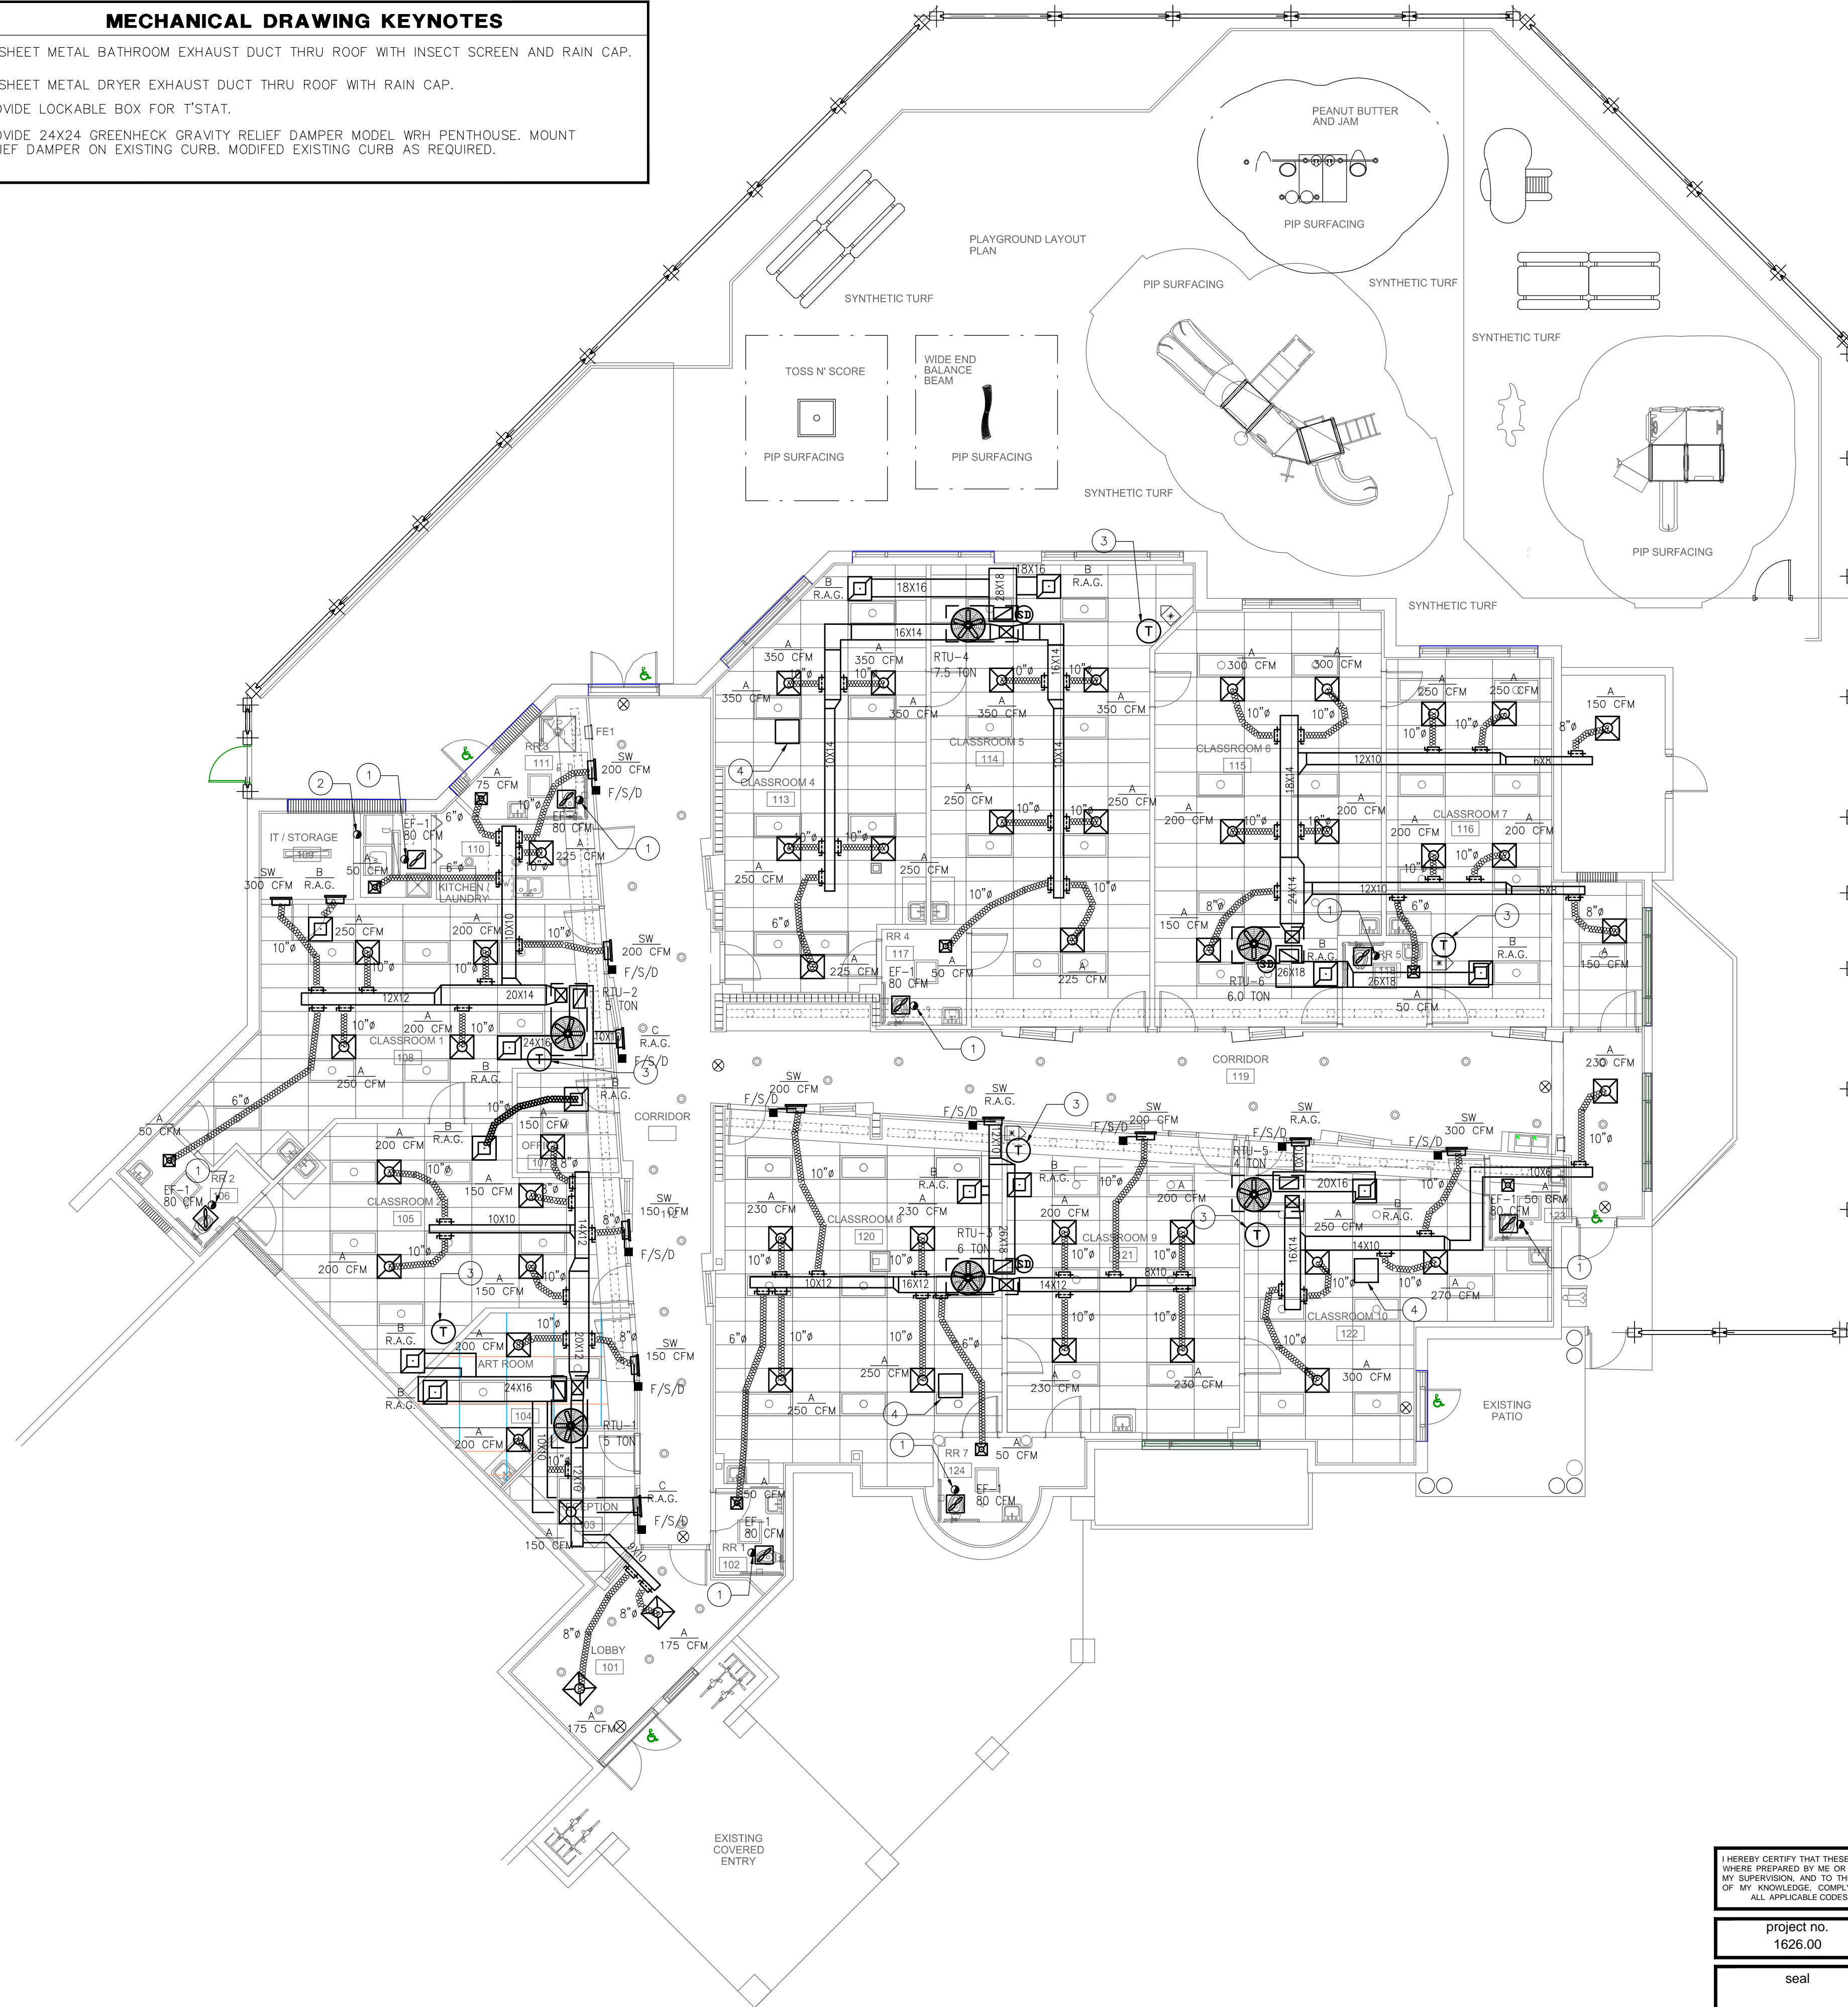

1ST FLOOR MECHANICAL PLAN
scale: 1/8" = 1'-0"

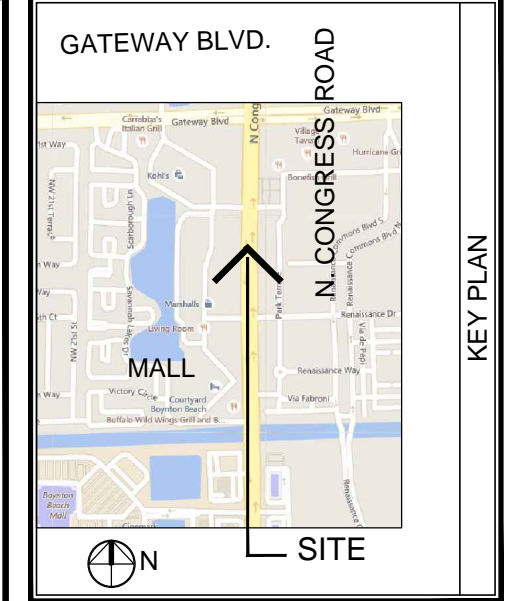

MARK	DESCRIPTION	DATE
▲		
▲		
▲		
▲		

MARC WIENER, A.I.A.
ARCHITECTURE/PLANNING
 AR # 0010416
 851 SOUTH FEDERAL HIGHWAY
 SUITE 803
 BOCA RATON, FLORIDA 33432
 561-750-4111 FAX: 561-750-5998

SOUTH FLORIDA SCHOOLS, LLC
 1820 SW 3RD AVENUE - STE 202
 MIAMI, FLORIDA 33129
 OFFICE: 904.596.3200
 FAX: 904.596.8550

KLA CHILDCARE
INTERIOR IMPROVEMENT
 1601 NORTH CONGRESS AVENUE
 BOYNTON BEACH, FLORIDA 33330

project no.
1626.00

seal

Viet Bach Nguyen, PE
 LICENSE No. 69753
 STATE OF FLORIDA

date

AMERICAN UNITED
Engineers Inc.
 Dedicated to Excellence

AUE 4508 SW 24th Street
 Fort Lauderdale, FL 33317
 Tel: (954) 471-8657
 american.eng@comcast.net
 CA # 29803

JOB NUMBER	15118
SCALE	AS NOTED
PROJECT DATE	16.03.22
ISSUE DATE	
BID DATE	
DRAWN BY	VBN
CHECKED BY	VBN
DISCIPLINE	MECHANICAL
PLAN TYPE	
SHEET NUMBER:	M-1

© 2015 MARC WIENER, A.I.A.