

1ST FLOOR PLUMBING SANITARY PLAN

scale: 1/8" = 1'-0"



I HEREBY CERTIFY THAT THESE PLANS WHERE PREPARED BY ME OR UNDER MY SUPERVISION AND TO THE BEST OF MY KNOWLEDGE COMPLY WITH ALL APPLICABLE CODES.

project no.
1626.00


seal

Viet Bach Nguyen, PE
LICENSE No. 69753
STATE OF FLORIDA

date

AMERICAN UNITED Engineers Inc.
Dedicated to Excellence

AUE 4508 SW 24th Street
Fort Lauderdale, FL 33317
Tel: (954) 471-8657
american.eng@comcast.net
CA # 29803

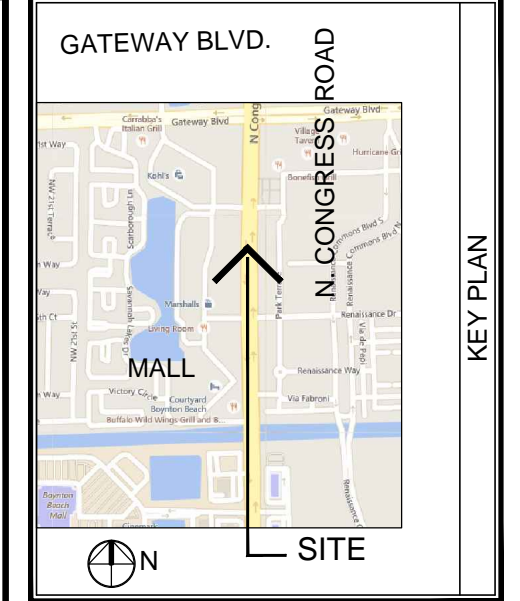

MARK	DESCRIPTION	DATE
▲		
▲		
▲		
▲		
▲		

MARC WIENER, A.I.A.
ARCHITECTURE/PLANNING

AR # 0010416
851 SOUTH FEDERAL HIGHWAY
SUITE 803
BOCA RATON, FLORIDA 33432
561-750-4111 FAX: 561-750-5098

ARCHITECT

SOUTH FLORIDA SCHOOLS, LLC
1820 SW 3RD AVENUE - STE 202
MIAMI, FLORIDA 33129

OFFICE: 904.596.3200
FAX: 904.596.8550

OWNER IDENTIFICATION

KLA CHILDCARE
INTERIOR IMPROVEMENT

1601 NORTH CONGRESS AVENUE
BOYNTON BEACH, FLORIDA 33330

BUILDING

JOB NUMBER	15118
SCALE	AS NOTED
PROJECT DATE	16.03.22
ISSUE DATE	
BID DATE	
DRAWN BY	VBN
CHECKED BY	VBN
DISCIPLINE	PLUMBING
PLAN TYPE	
SHEET NUMBER:	P-1

PROJECT

SHEET

© 2015 MARC WIENER, A.I.A.