



RODOLFO ACEVEDO AIA
 JAMES R. WILLIAMS AIA
 7700 CONGRESS AVE.
 SUITE 1114
 BOCA RATON, FLORIDA 33487
 TEL. 561 997 1244
 FAX 561 997 1675


BOCA GROVE PLANTATION
 CLUB HOUSE

21351 WHITAKER DRIVE,
 BOCA RATON, FL 33433

FLORIDA LICENSURE: AA26002219

PROJECT NO. 15155
 DESIGNED BY: RA/JW
 DRAWN BY: TD/CE/MA
 CHECKED BY: RA/JW
 SUBMITTALS:
 PERMIT SET 04.07.2016

REVISIONS:

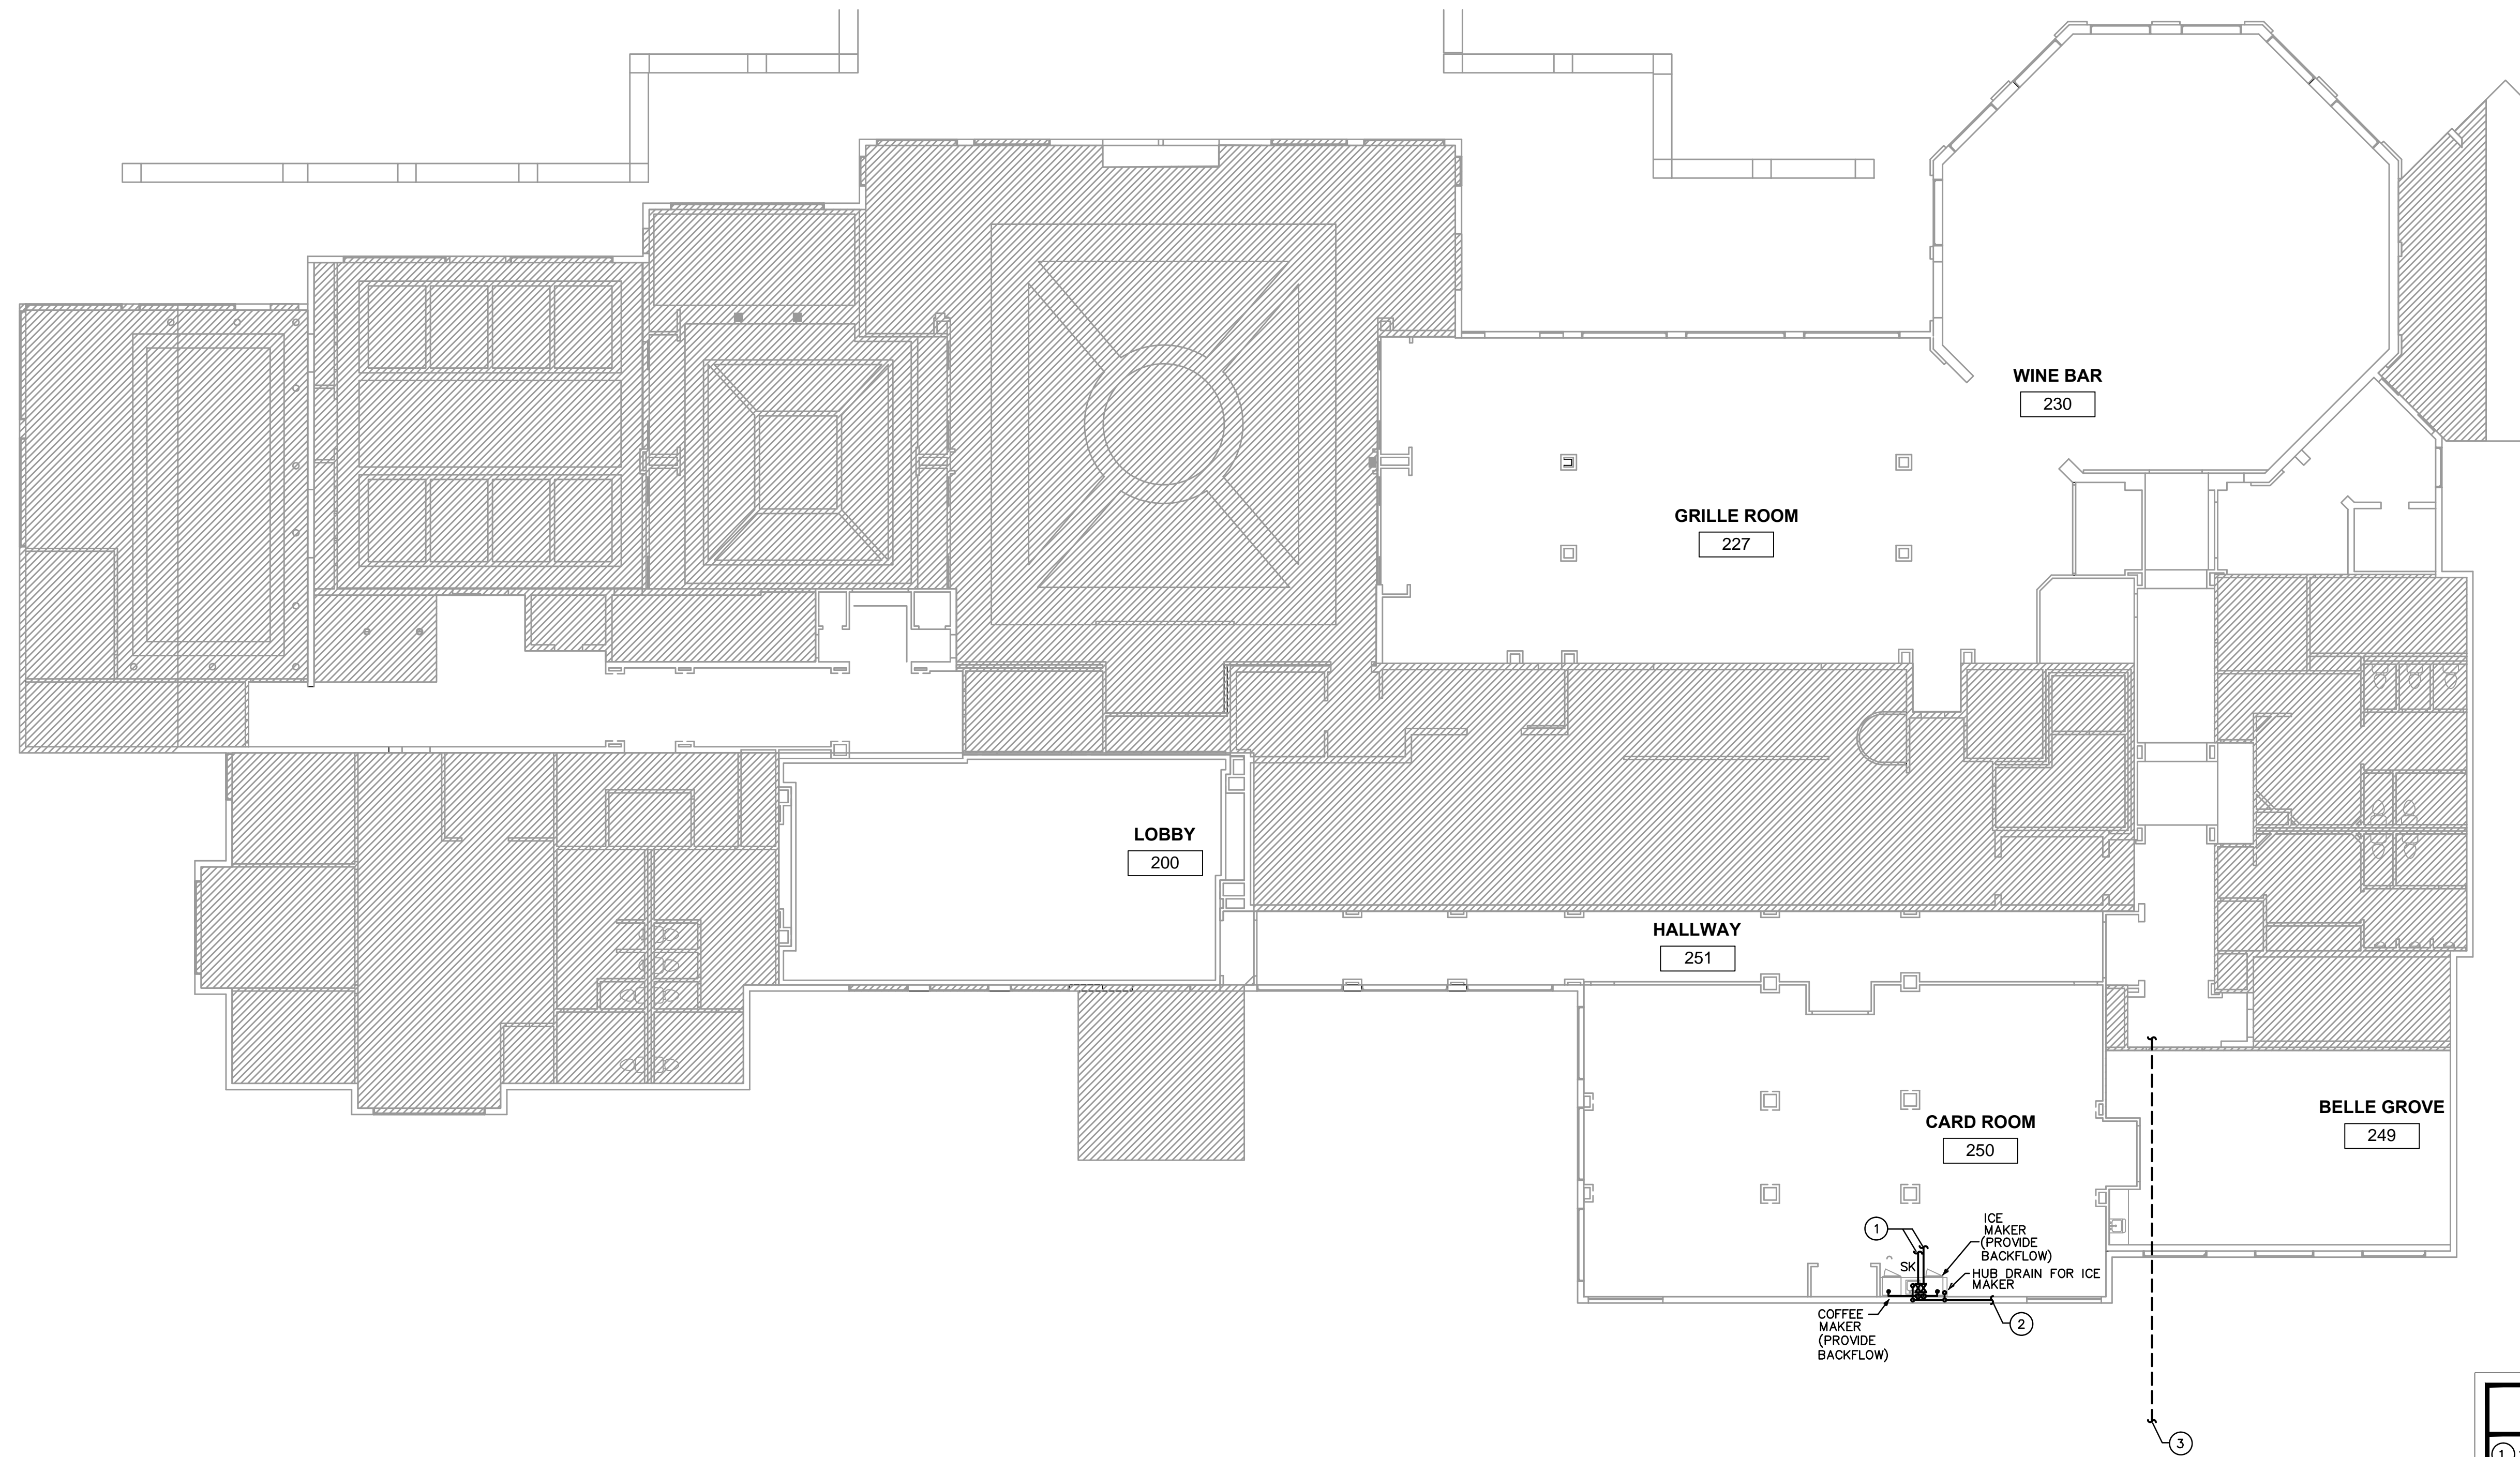

PLUMBING PLAN
 3/32"=1'-0"

- KEY NOTES**
- 3/4" DOMESTIC WATER LINE, TIE TO EXISTING. FIELD VERIFY EXACT SIZE AND LOCATION PRIOR TO CONSTRUCTION.
 - 2" SANITARY LINE, TIE TO EXISTING. FIELD VERIFY EXACT SIZE, LOCATION, AND INVERT PRIOR TO CONSTRUCTION.
 - EXISTING 4" SANITARY LINE. FIELD VERIFY EXACT LOCATION AND INVERT PRIOR TO CONSTRUCTION.

ISSUED FOR PERMIT ONLY		04-18-16
KAMM CONSULTING PROJECT # 2016-0292 PROJECT MANAGER: JOHN MAYR		
 1408 Orange Avenue Fort Pierce, Florida 34950 Phone 772.595.1744 Fax 772.595.1745 bbrown@kammconsulting.com Certification of Authorization #8189		
PRINCIPAL Brady L. Brown	Florida License #58232	04-18-16 date
		signed

PLUMBING PLAN