


1.	
2.	
3.	
4.	
5.	
6.	
7.	
8.	
9.	
10.	

ALL DIMENSIONS, MATERIALS, AND FINISHES SHALL BE AS SHOWN ON THE DRAWINGS. THE CONTRACTOR SHALL BE RESPONSIBLE FOR OBTAINING ALL NECESSARY PERMITS AND APPROVALS FROM THE LOCAL, STATE, AND FEDERAL AGENCIES. THE CONTRACTOR SHALL BE RESPONSIBLE FOR OBTAINING ALL NECESSARY PERMITS AND APPROVALS FROM THE LOCAL, STATE, AND FEDERAL AGENCIES. THE CONTRACTOR SHALL BE RESPONSIBLE FOR OBTAINING ALL NECESSARY PERMITS AND APPROVALS FROM THE LOCAL, STATE, AND FEDERAL AGENCIES.

FIRE SPRINKLER LEGEND	
●	RECESSED SPRINKLER HEAD
○	UP RIGHT SPRINKLER HEAD ABOVE FLOATING CEILING AND RECESSED HEAD IN FLOATING CEILING.
AUTOMATIC SPRINKLER SYSTEM	
FURNISH AND INSTALL A COMPLETE WET PIPE SPRINKLER SYSTEM AS INDICATED ON THE PLANS. SPRINKLER HEADS AS SHOWN ON THE DRAWINGS. THE SYSTEM(S) SHALL BE INSTALLED TO MEET INSURERS, AGENCY GUIDELINES, NFPA STATE AND LOCAL CODE REQUIREMENTS AND THE REQUIREMENTS OF THESE DOCUMENTS. NO PART OR SECTION OF NFPA SHALL BE VIOLATED. THE A/S SYSTEM(S) SHALL BE ZONED AS SHOWN ON THE DRAWINGS.	

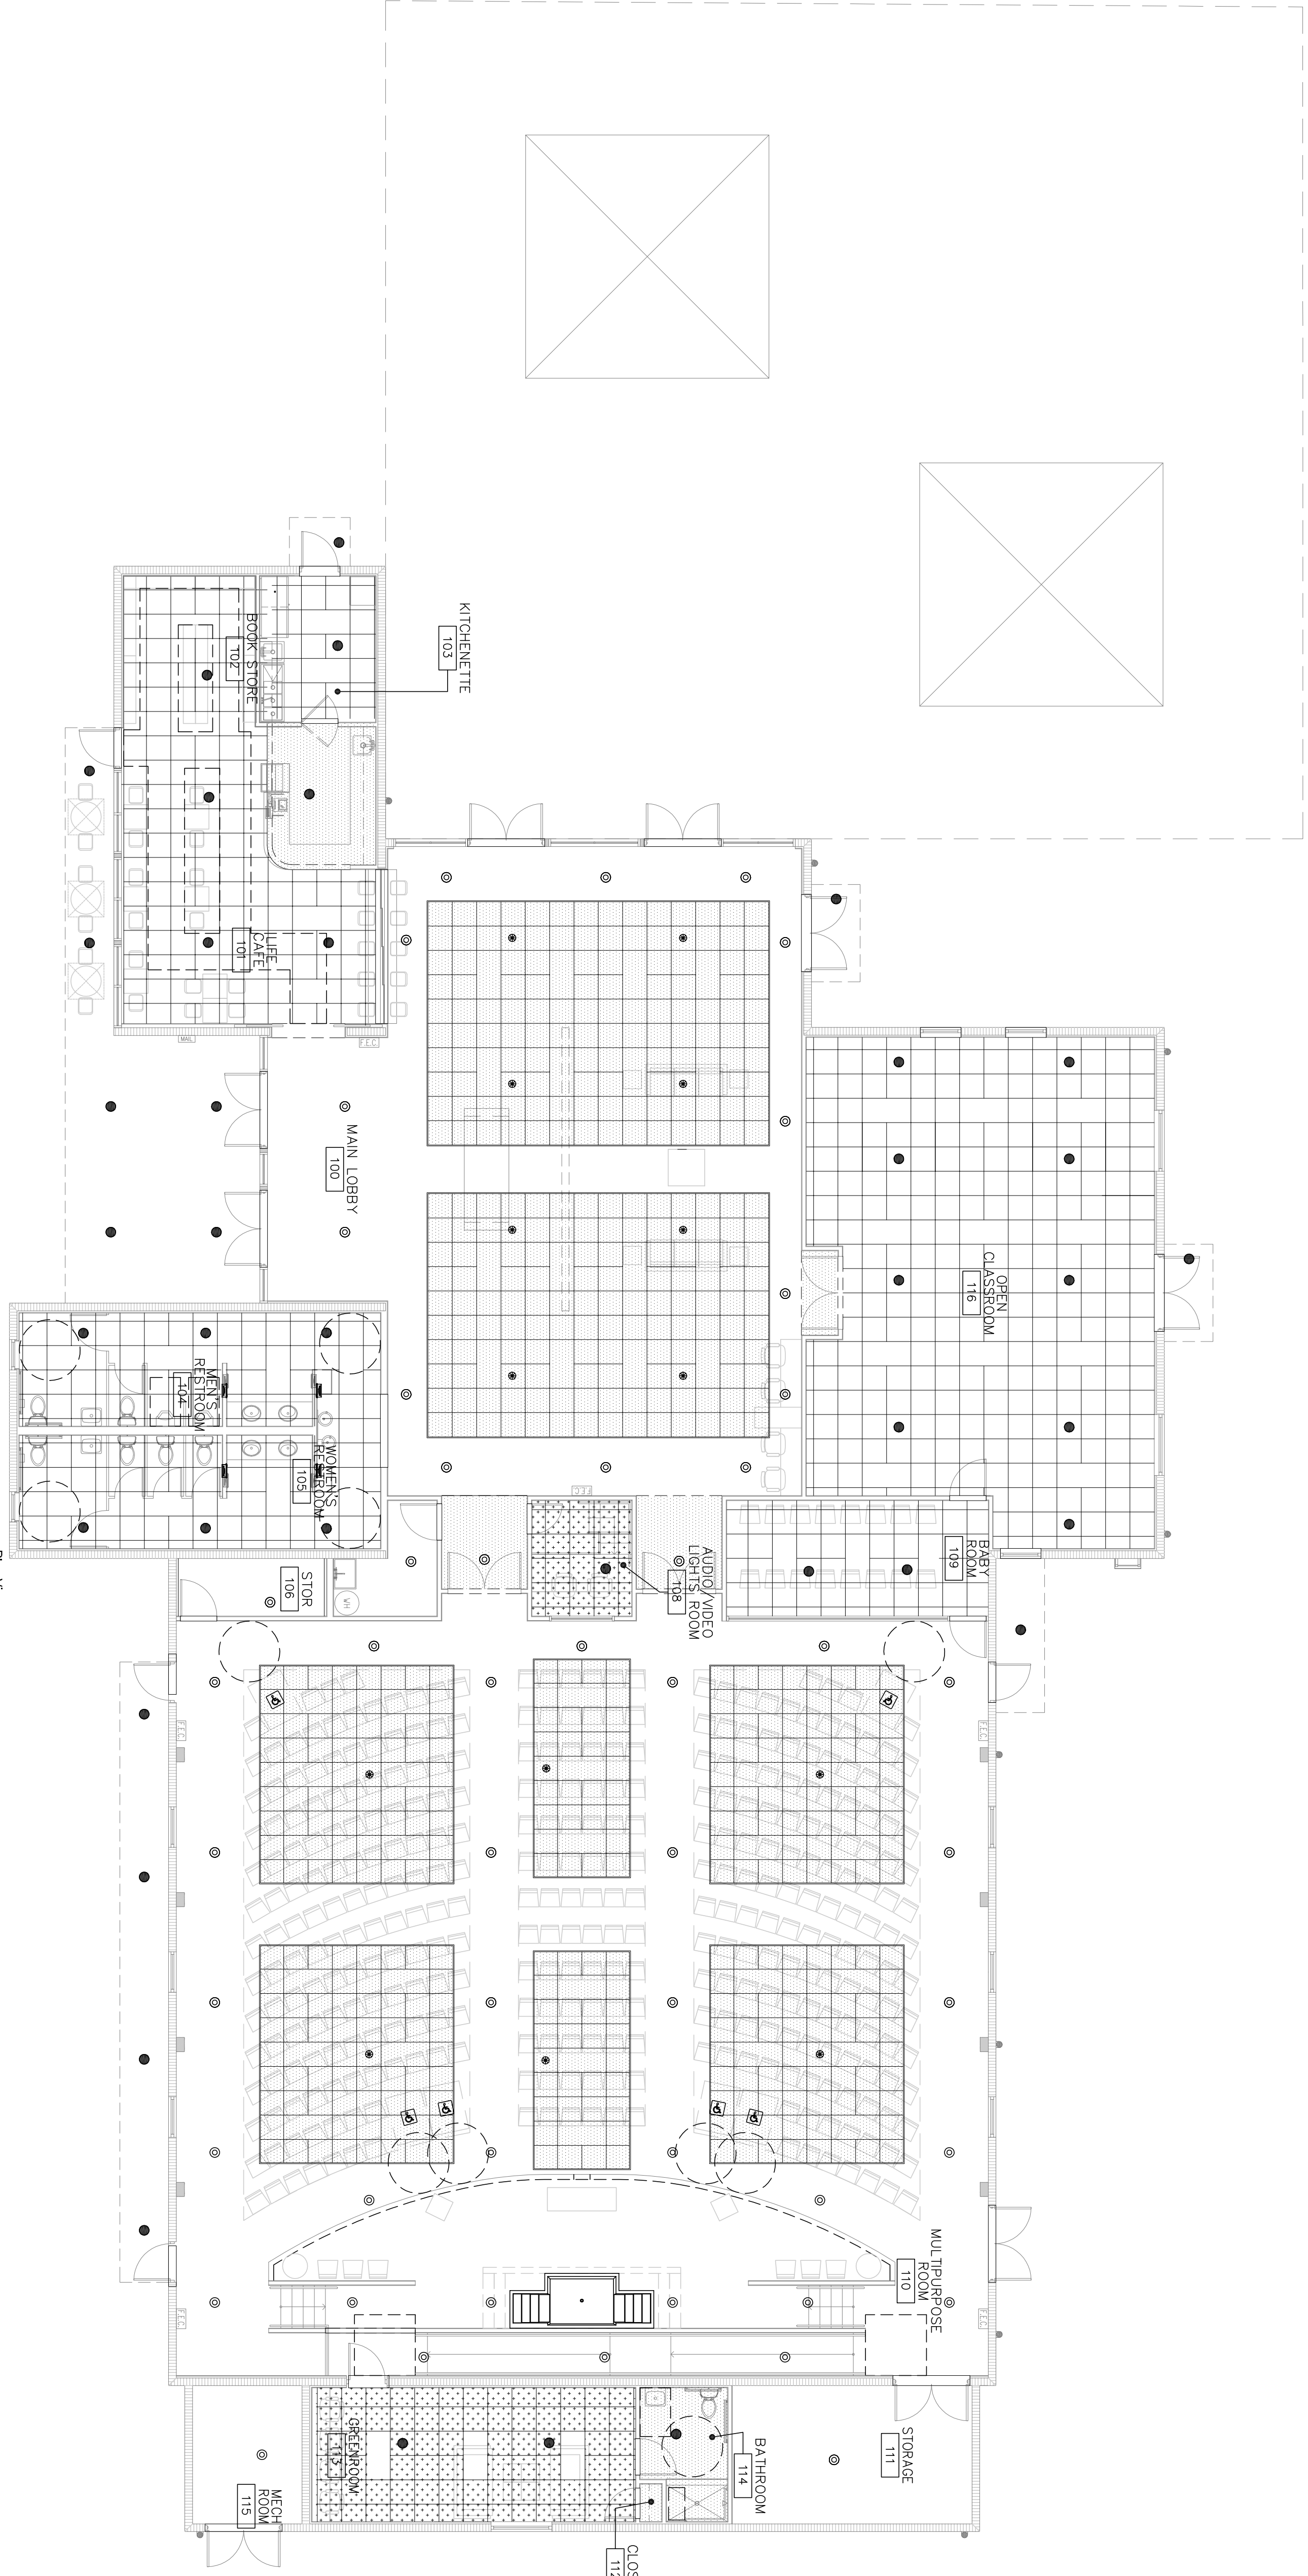

CONCEPTUAL FIRE SPRINKLER PLAN
 SCALE: 1/8" = 1'-0"
 PLAN VIEW
 Scale: 1" = 8'

PROGRESS OR CHECK SETS, BY THEIR NATURE, MAY BE INCOMPLETE AND ARE NOT TO BE USED FOR BIDDING OR CONSTRUCTION. CONTRACTOR RECOGNIZES HIS SOLE RESPONSIBILITY TO INCLUDE ALL COMMERCIALS FOR DESIGN AND INSTALLATION TO MEET THE PROJECT REQUIREMENTS IN ANY PENDING EXERCISE. THE DESIGN OF THESE PLANS ARE NOT FINAL UNTIL PERMITS ARE ISSUED.

PRIOR TO SUBMITTING THE BID, THE CONTRACTOR SHALL VERIFY ALL EXISTING CONDITIONS AND THE EXISTING CONDITIONS AND SHALL INCLUDE IN THE BID TO CORRECT THE SAME AS DIRECTED BY THE ENGINEER AND THE ARCHITECT. ARE NOT RESPONSIBLE FOR ANY ADDITIONAL COSTS RESULTING FROM UNRECOVERABLE EXISTING CONDITIONS DISCOVERED AFTER CONTRACT HAS BEEN AWARDED. NO CHANGES SHALL BE MADE TO THESE PLANS WITHOUT PRIOR APPROVAL FROM THE ENGINEER OF RECORD. ALL CHANGES SHALL BE SUBMITTED FOR REVIEW PRIOR TO INSTALLATION. NOT FOR BID UNTIL PERMIT HAS BEEN ISSUED.

CA. LIC. No. 31328

Associated Professional Design
 Consulting Engineers
 5000 NE 97th AVENUE BLVD, SUITE 205, BOCA RATON, FLORIDA 33491
 PHONE: 561.492.8977; INFO@APD-ENGINEERING.COM
 MARTIN WATKINS, P.E., FLORIDA LICENSE NO. 593999

CHECK SET: 05/20/16

FS1.1

JUAN C. LINARES

A.25000640

LIFE FELLOWSHIP
 11401 WEST SAMPLE ROAD
 CORAL SPRINGS, FL. 33065

RWB
Linares
 ARCHITECTURE
 1600 SOUTH DIXIE HWY., SUITE 400
 BOCA RATON, FLORIDA 33432
 PHONE 561-391-0081 FAX 561-391-0085
 EMAIL mail@rwb-arch.com

PROJECT # 16024
 DATE 05-20-16
 SHEET #