

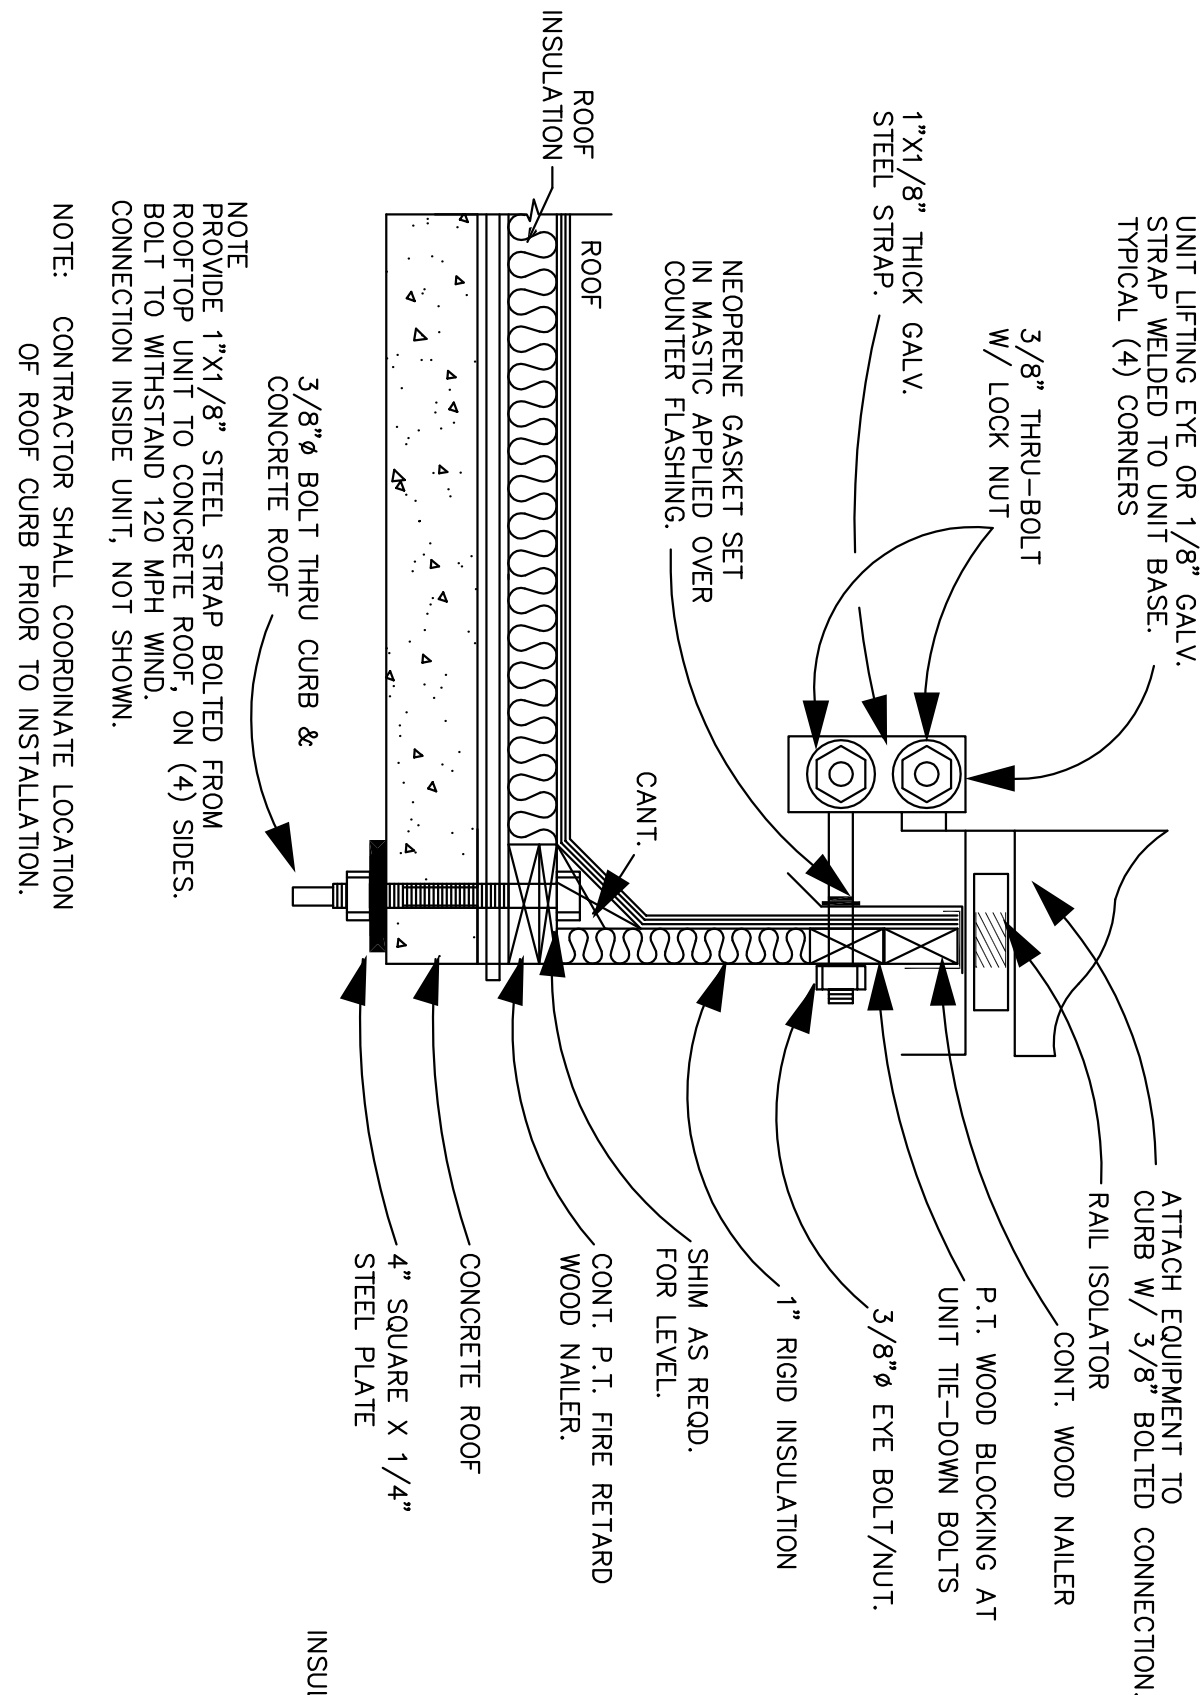





# 1 MECHANICAL DETAILS PLAN

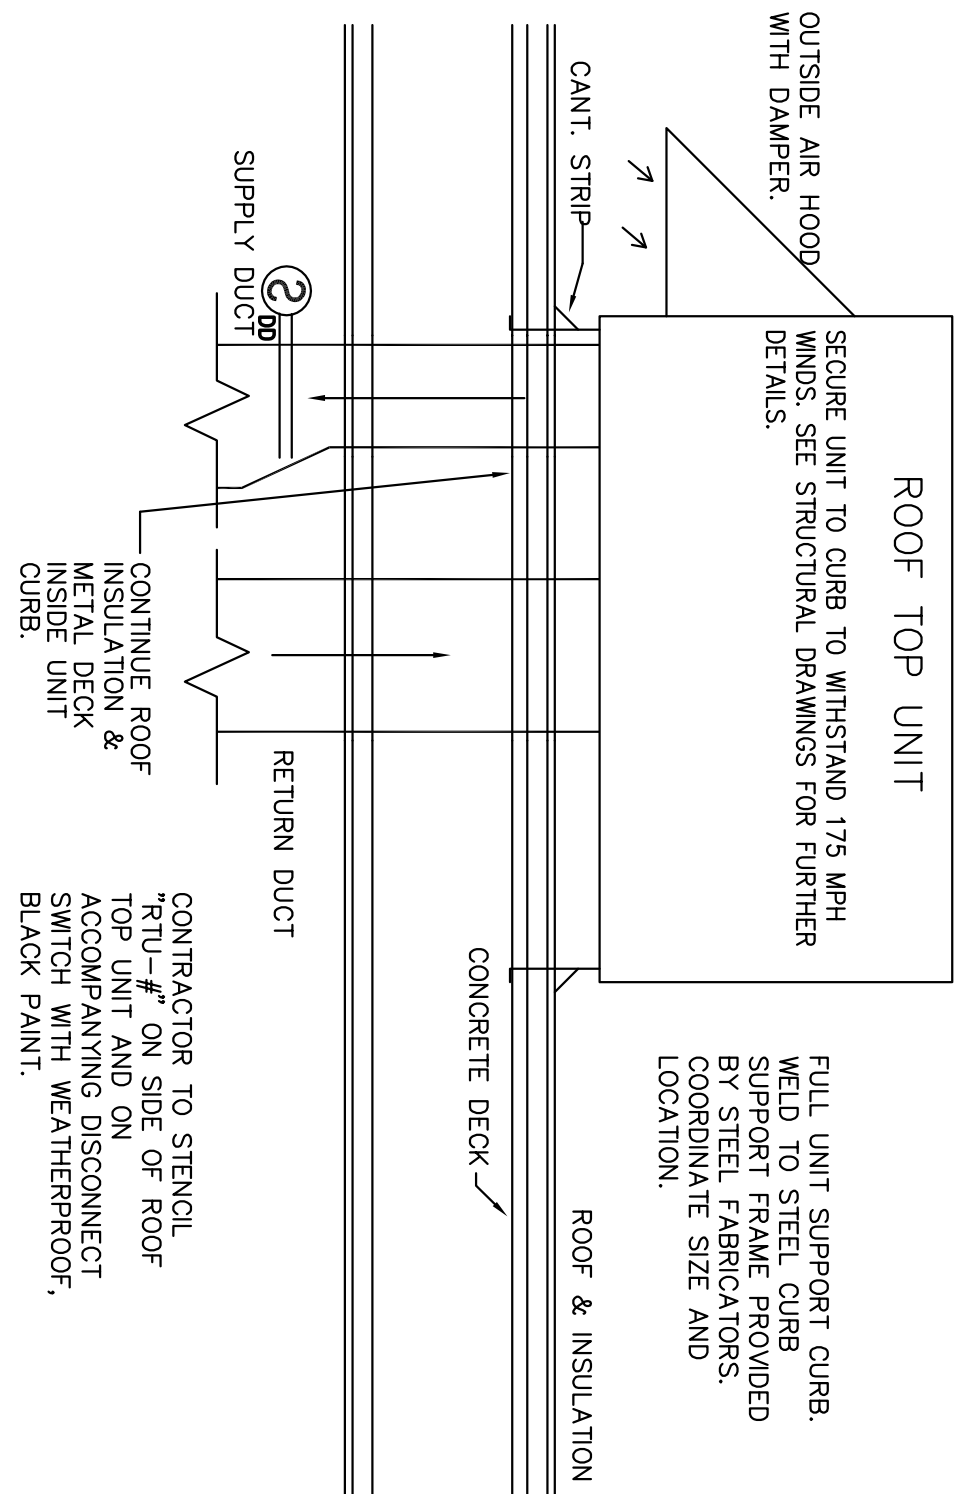


### HVAC ROOF CURB DETAIL

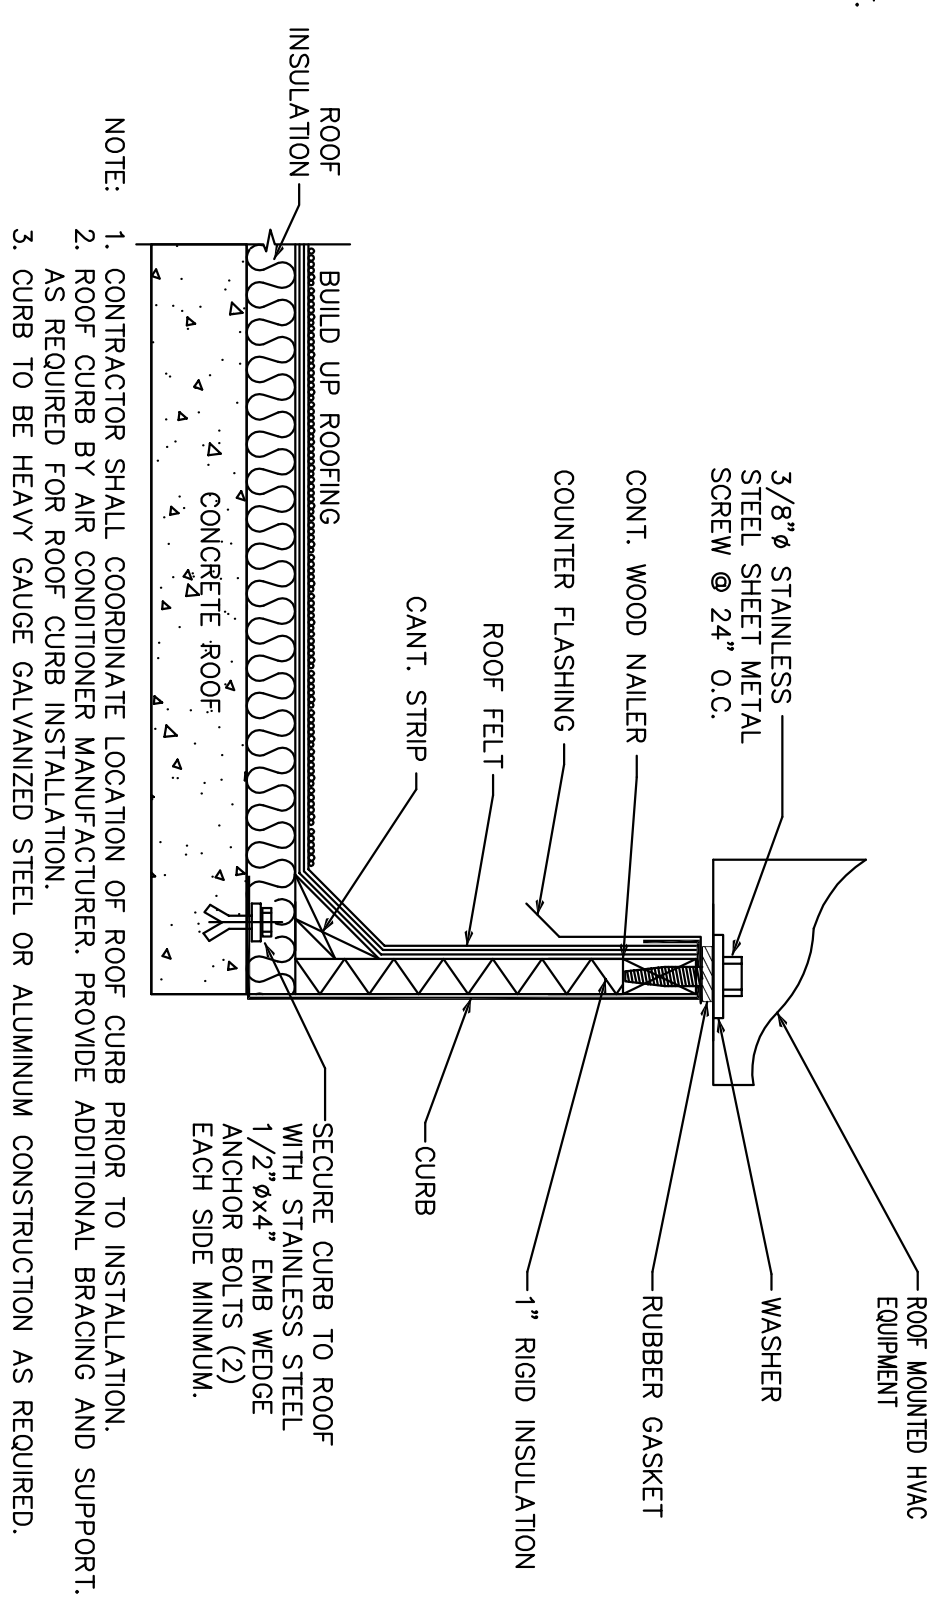

 
## REFRIGERANT PIPE RAINCOVER DETAIL

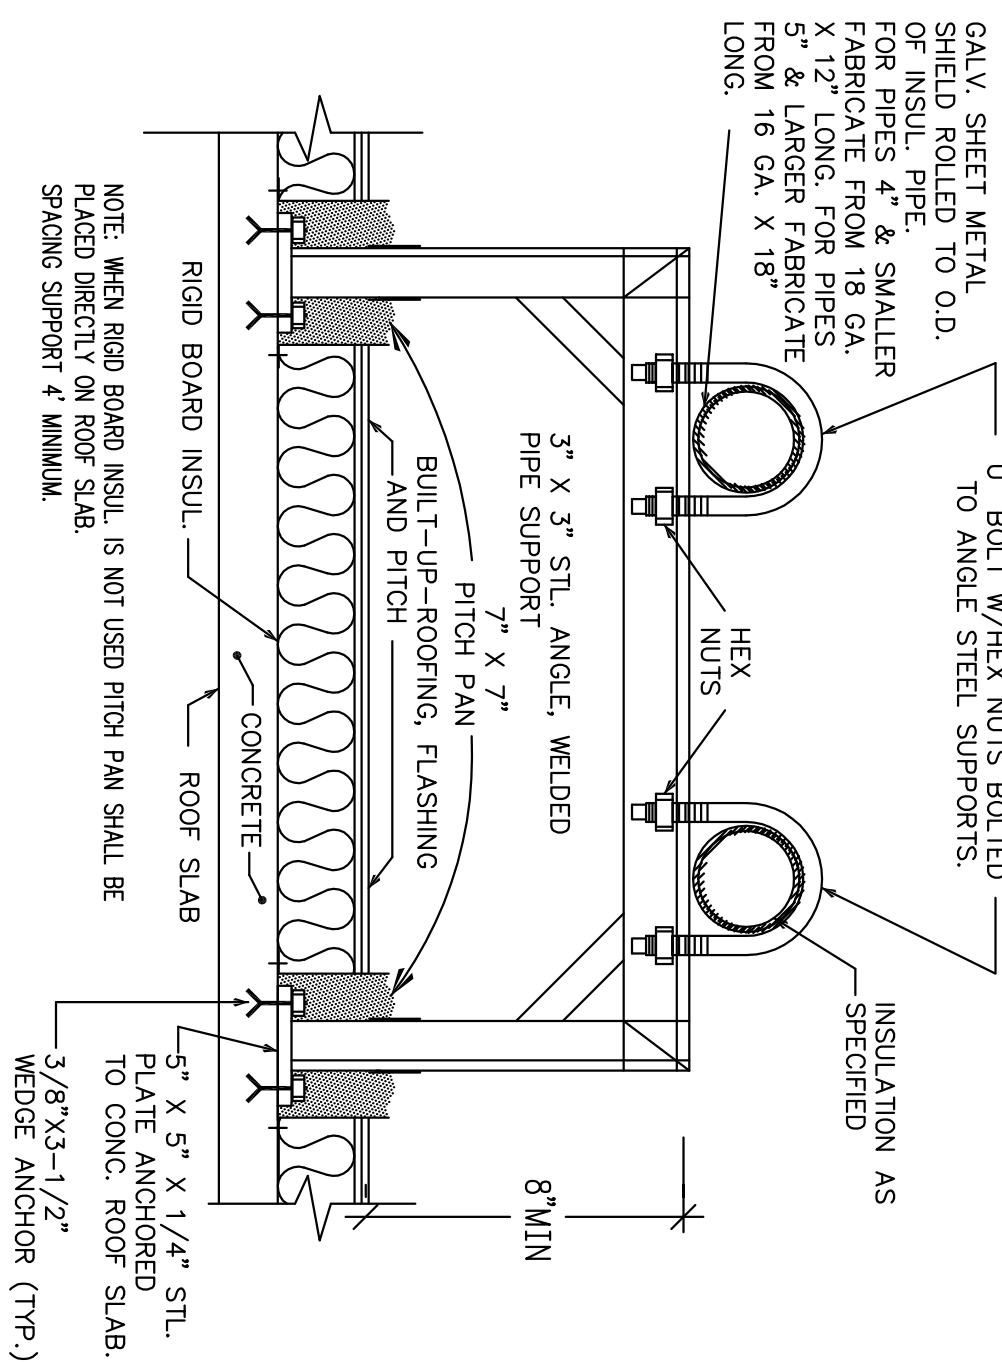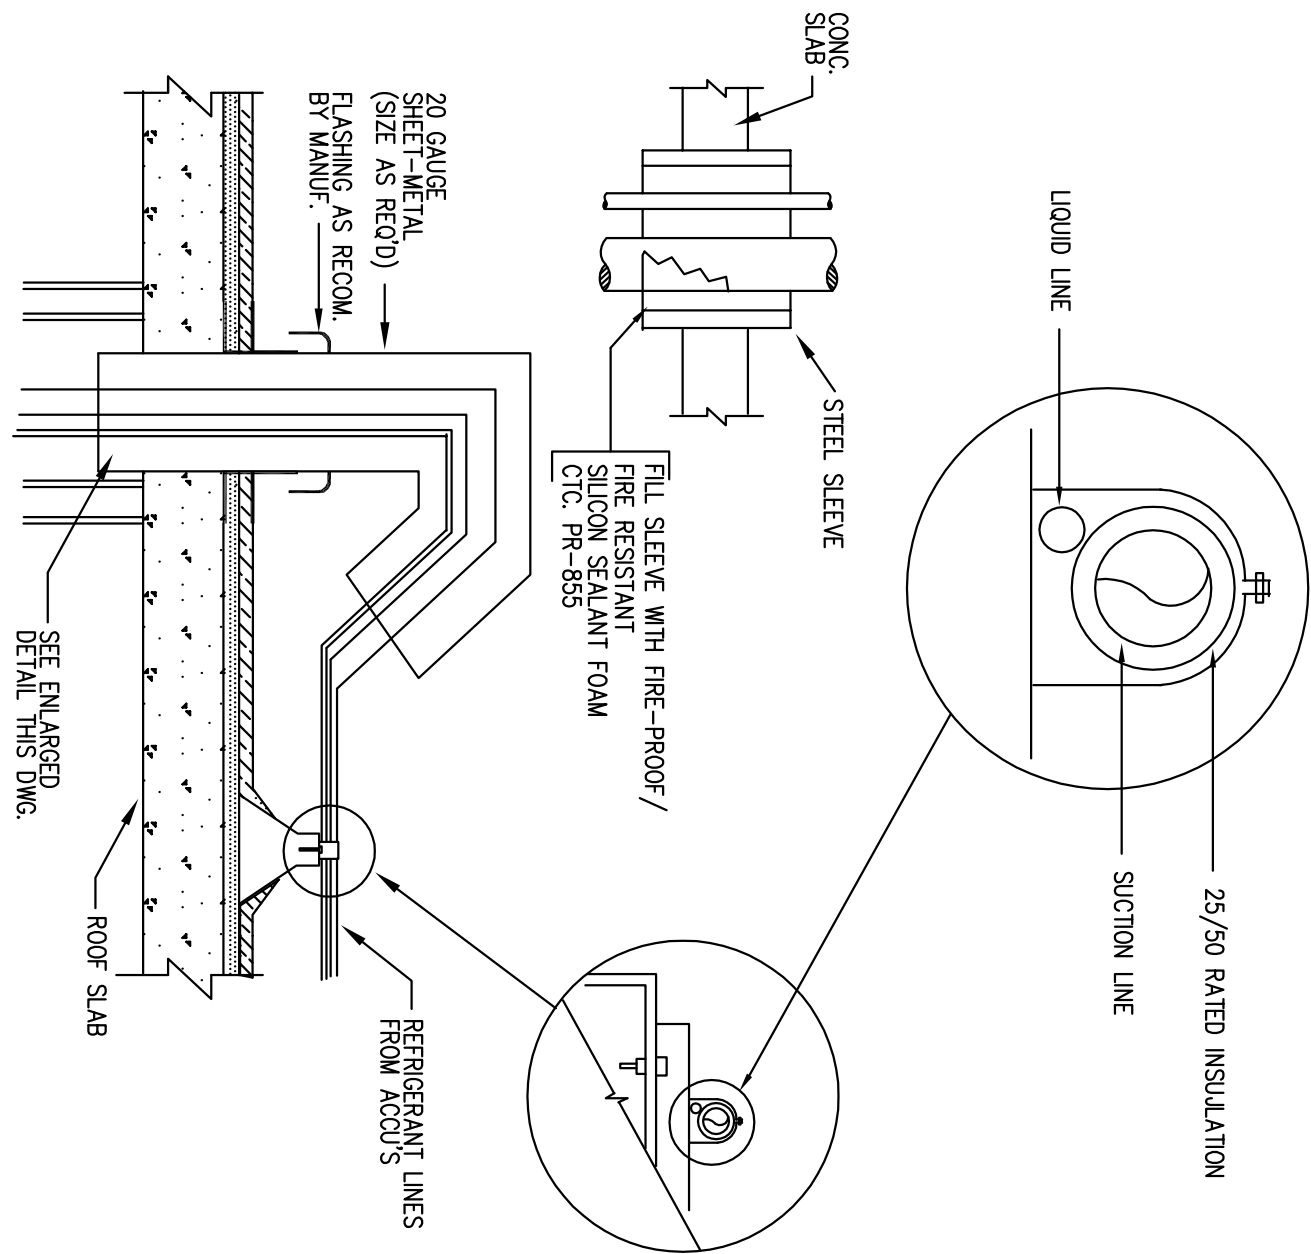


## ROOF CAP DETAIL

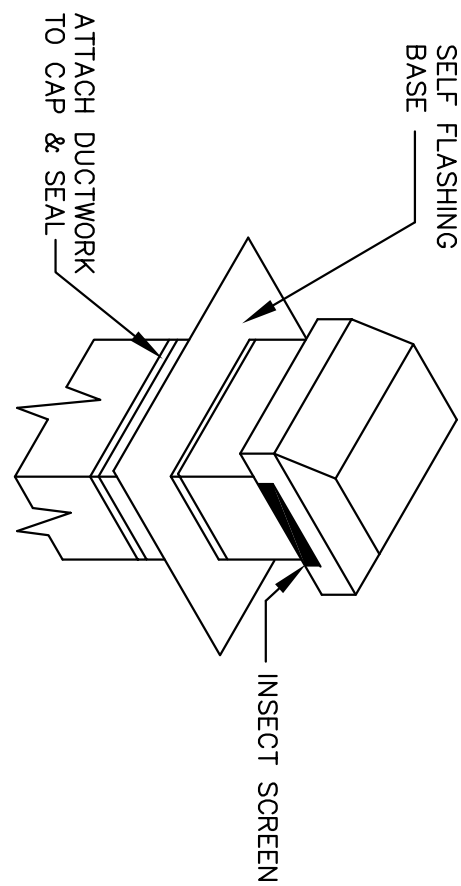


### CABINET EXHAUST FAN DETAIL

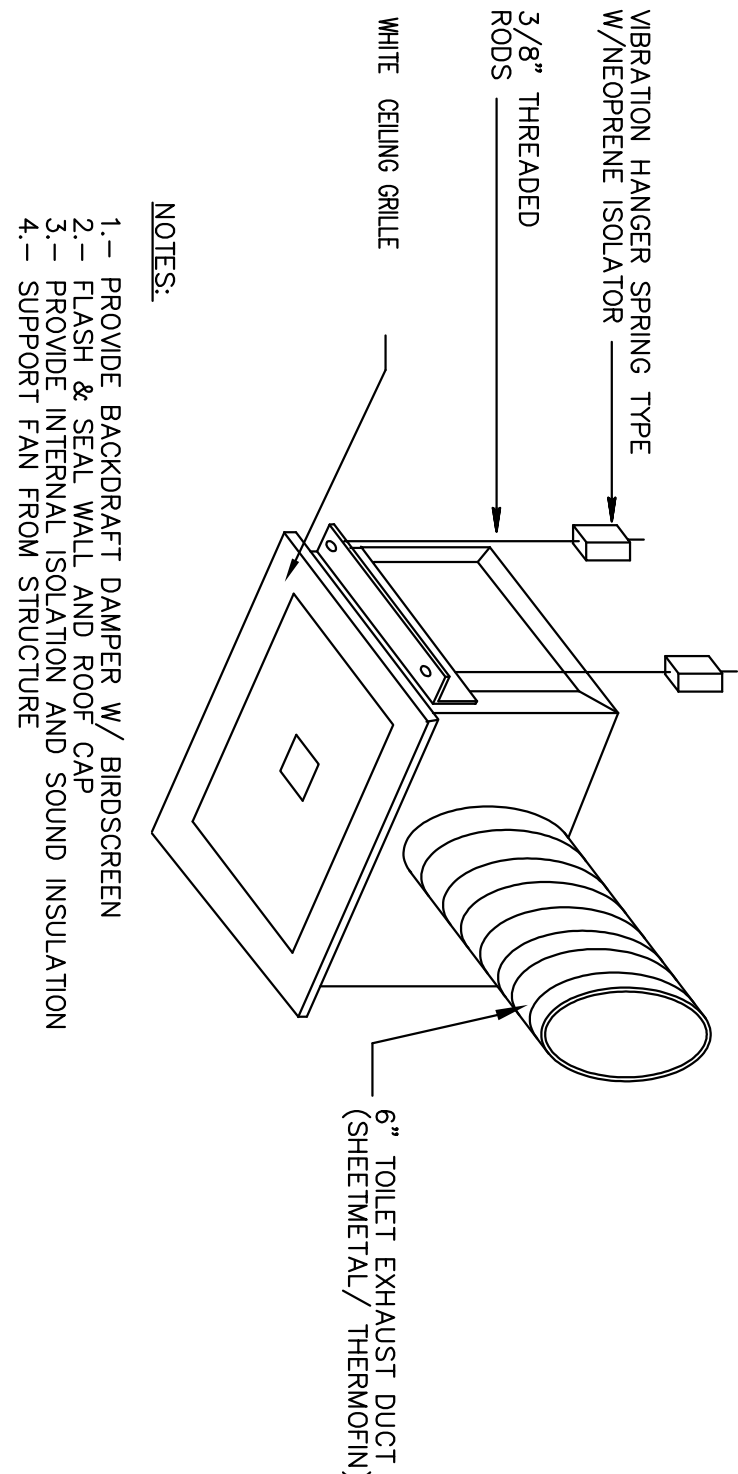

## CONNECTIONS TO RTU

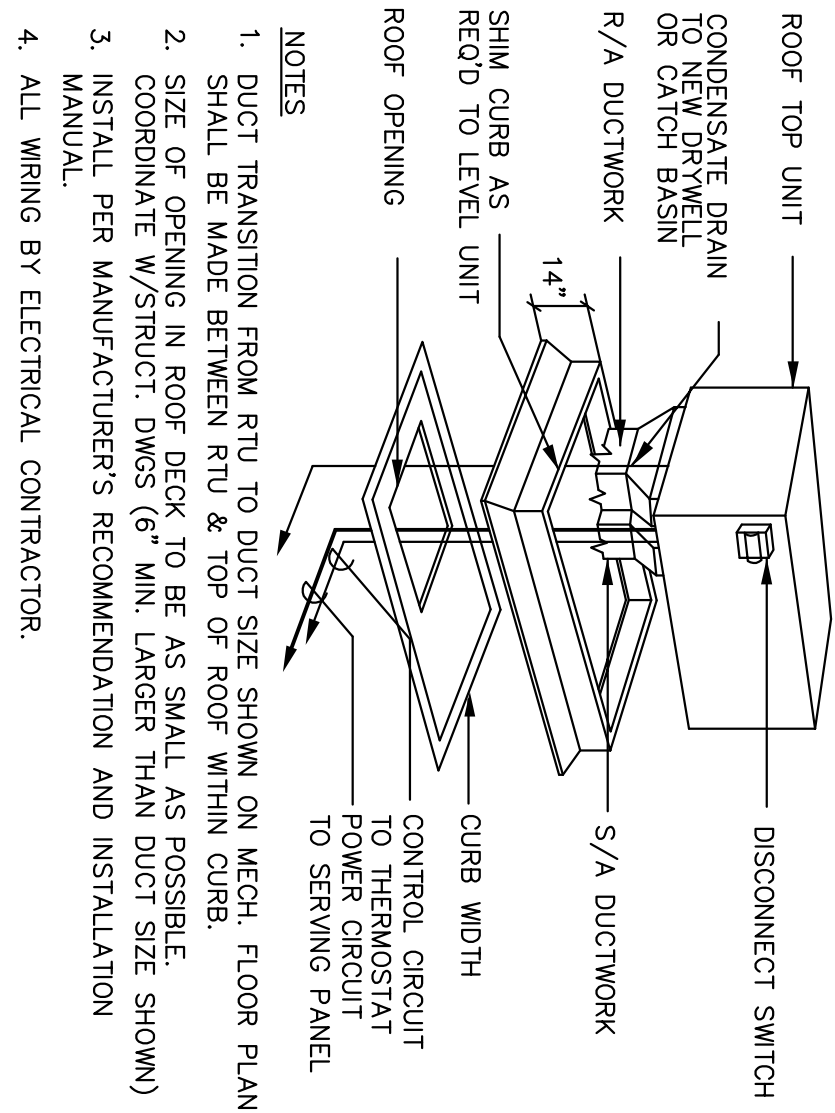

1.7.11.1  
N.T.S.

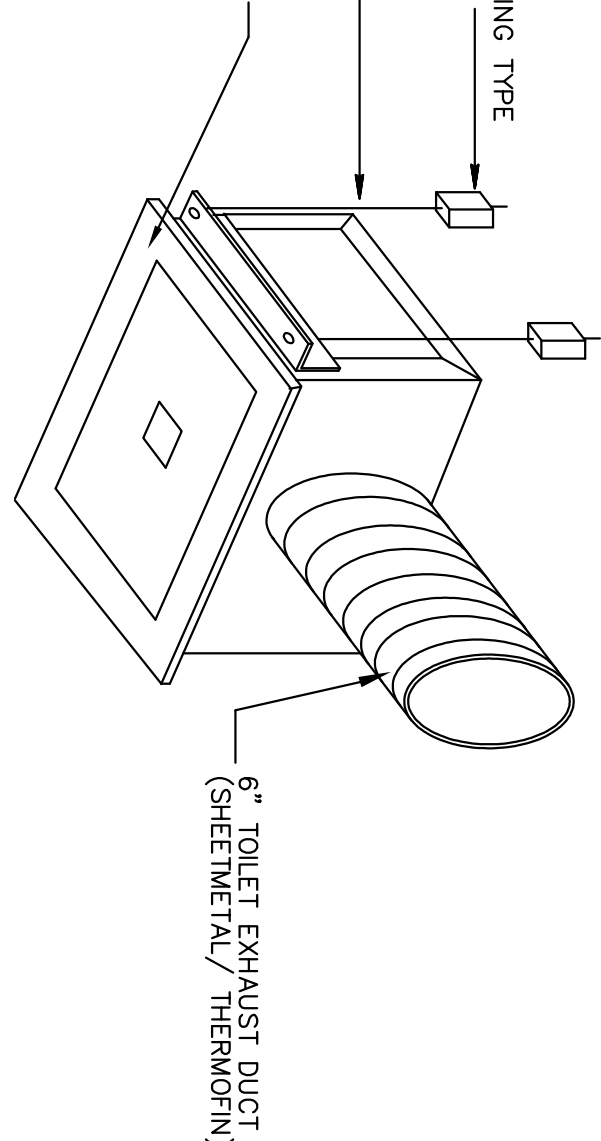

### CABINET EXHAUST FAN DETAIL

1.7.11.1  
N.T.S.

MECHANICAL  
DETAILS PLAN

SHEET NUMBER

## M-9

**SYNALOVSKI ROMANIK & ASSOCIATES**  
Architecture • Planning • Interior Design

1800 Eller Drive, Suite 500  
Fort Lauderdale, FL 33316

T 954.961.6806  
F 954.961.6807

[www.synalovski.com](http://www.synalovski.com)

Manuel Synalowski, ALA  
AR 0011628  
SEAL

LICENSE NO. AA26001863

# VILLAGE AT ATLANTIC SHORES

801 N. FEDERAL HIGHWAY  
HALLANDALE BEACH, FL

801 N. FEDERAL HIGHWAY  
HALLANDALE BEACH, FL

CLIENT: ATLANTIC VILLAGE 1, LLC.

[illegible]

SHEET TITLE

JOB # 16-0402

Amarilis Rodriguez, P.E.  
License Number 60236  
C.A. 26359

C.A. 26359

Signature \_\_\_\_\_

and

**M-9**