





GENERAL NOTES

1. THE CONTRACTOR IS RESPONSIBLE FOR THE MAINTENANCE OF ALL UNDERGROUND UTILITIES.
2. REGULATIONS - ALL CONSTRUCTION SHALL BE IN ACCORDANCE WITH THE FLORIDA DEPARTMENT OF TRANSPORTATION STANDARDS & SPECIFICATIONS (LATEST EDITION) AND ALL APPLICABLE LOCAL REGULATIONS.
3. GUARANTEE - ALL MATERIAL AND EQUIPMENT TO BE FURNISHED AND/OR INSTALLED BY THE CONTRACTOR UNDER THIS CONTRACT SHALL BE GUARANTEED FOR A PERIOD OF ONE YEAR FROM THE DATE OF ACCEPTANCE THEREOF AGAINST DEFECTIVE MATERIALS, DESIGN AND WORKMANSHIP. UPON NOTICE FROM THE OWNER OF FAILURE OF ANY PARTS OR MATERIALS, THOSE PARTS OR MATERIALS SHALL BE REPLACED PROMPTLY AT NO EXPENSE TO THE OWNER.
4. ELEVATIONS SHOWN ARE BASED ON NORTH AMERICAN VERTICAL DATUM OF 1988 (NAVD 88).

DRAINAGE NOTES:
 1. YARD DRAINS SHALL BE 12" NYLOPLAST INLINE DRAIN WITH H-20 RATED STANDARD GRATE.

LEGEND

- 12.70 PROPOSED ELEVATION
- 12.50 EXISTING ELEVATION
- ~ FLOW ARROW
- CONCRETE PAVEMENT

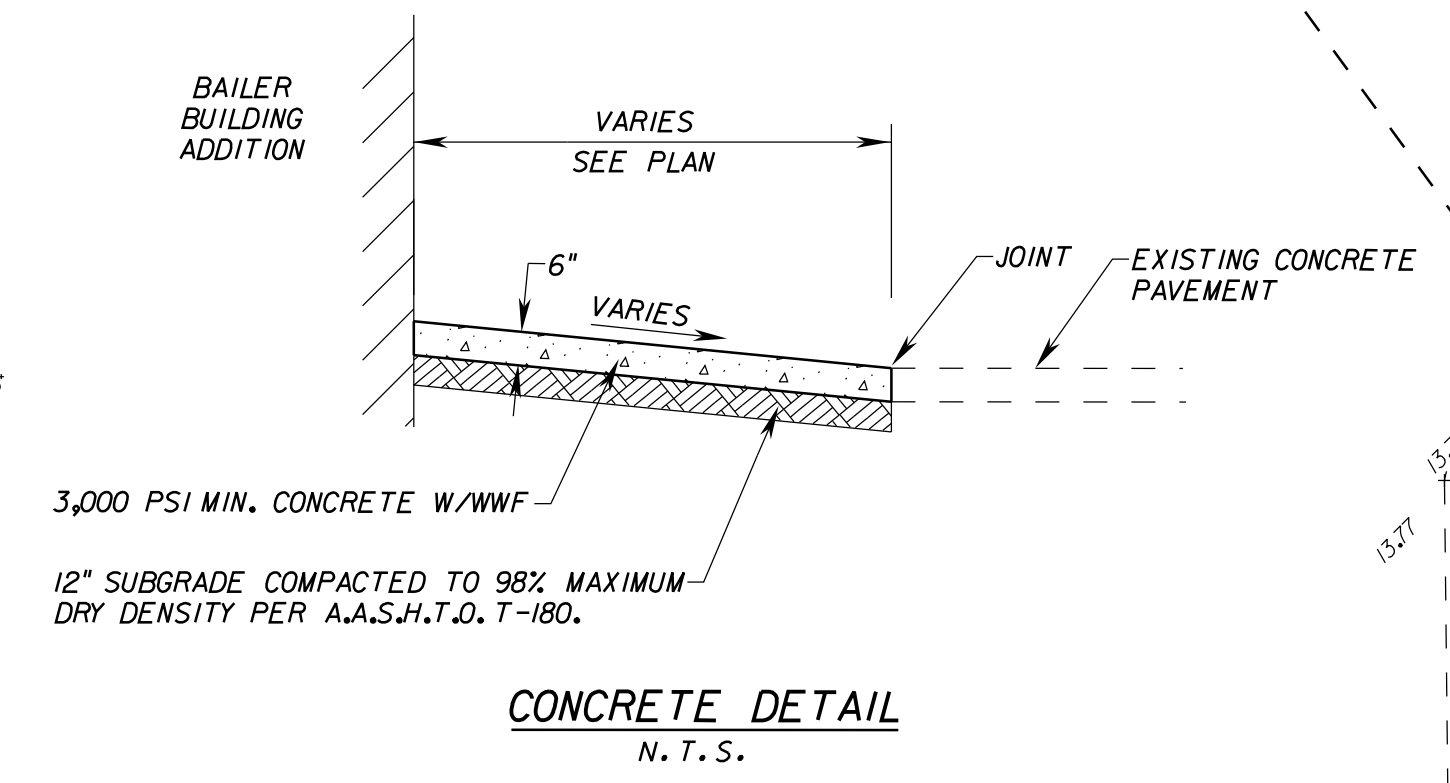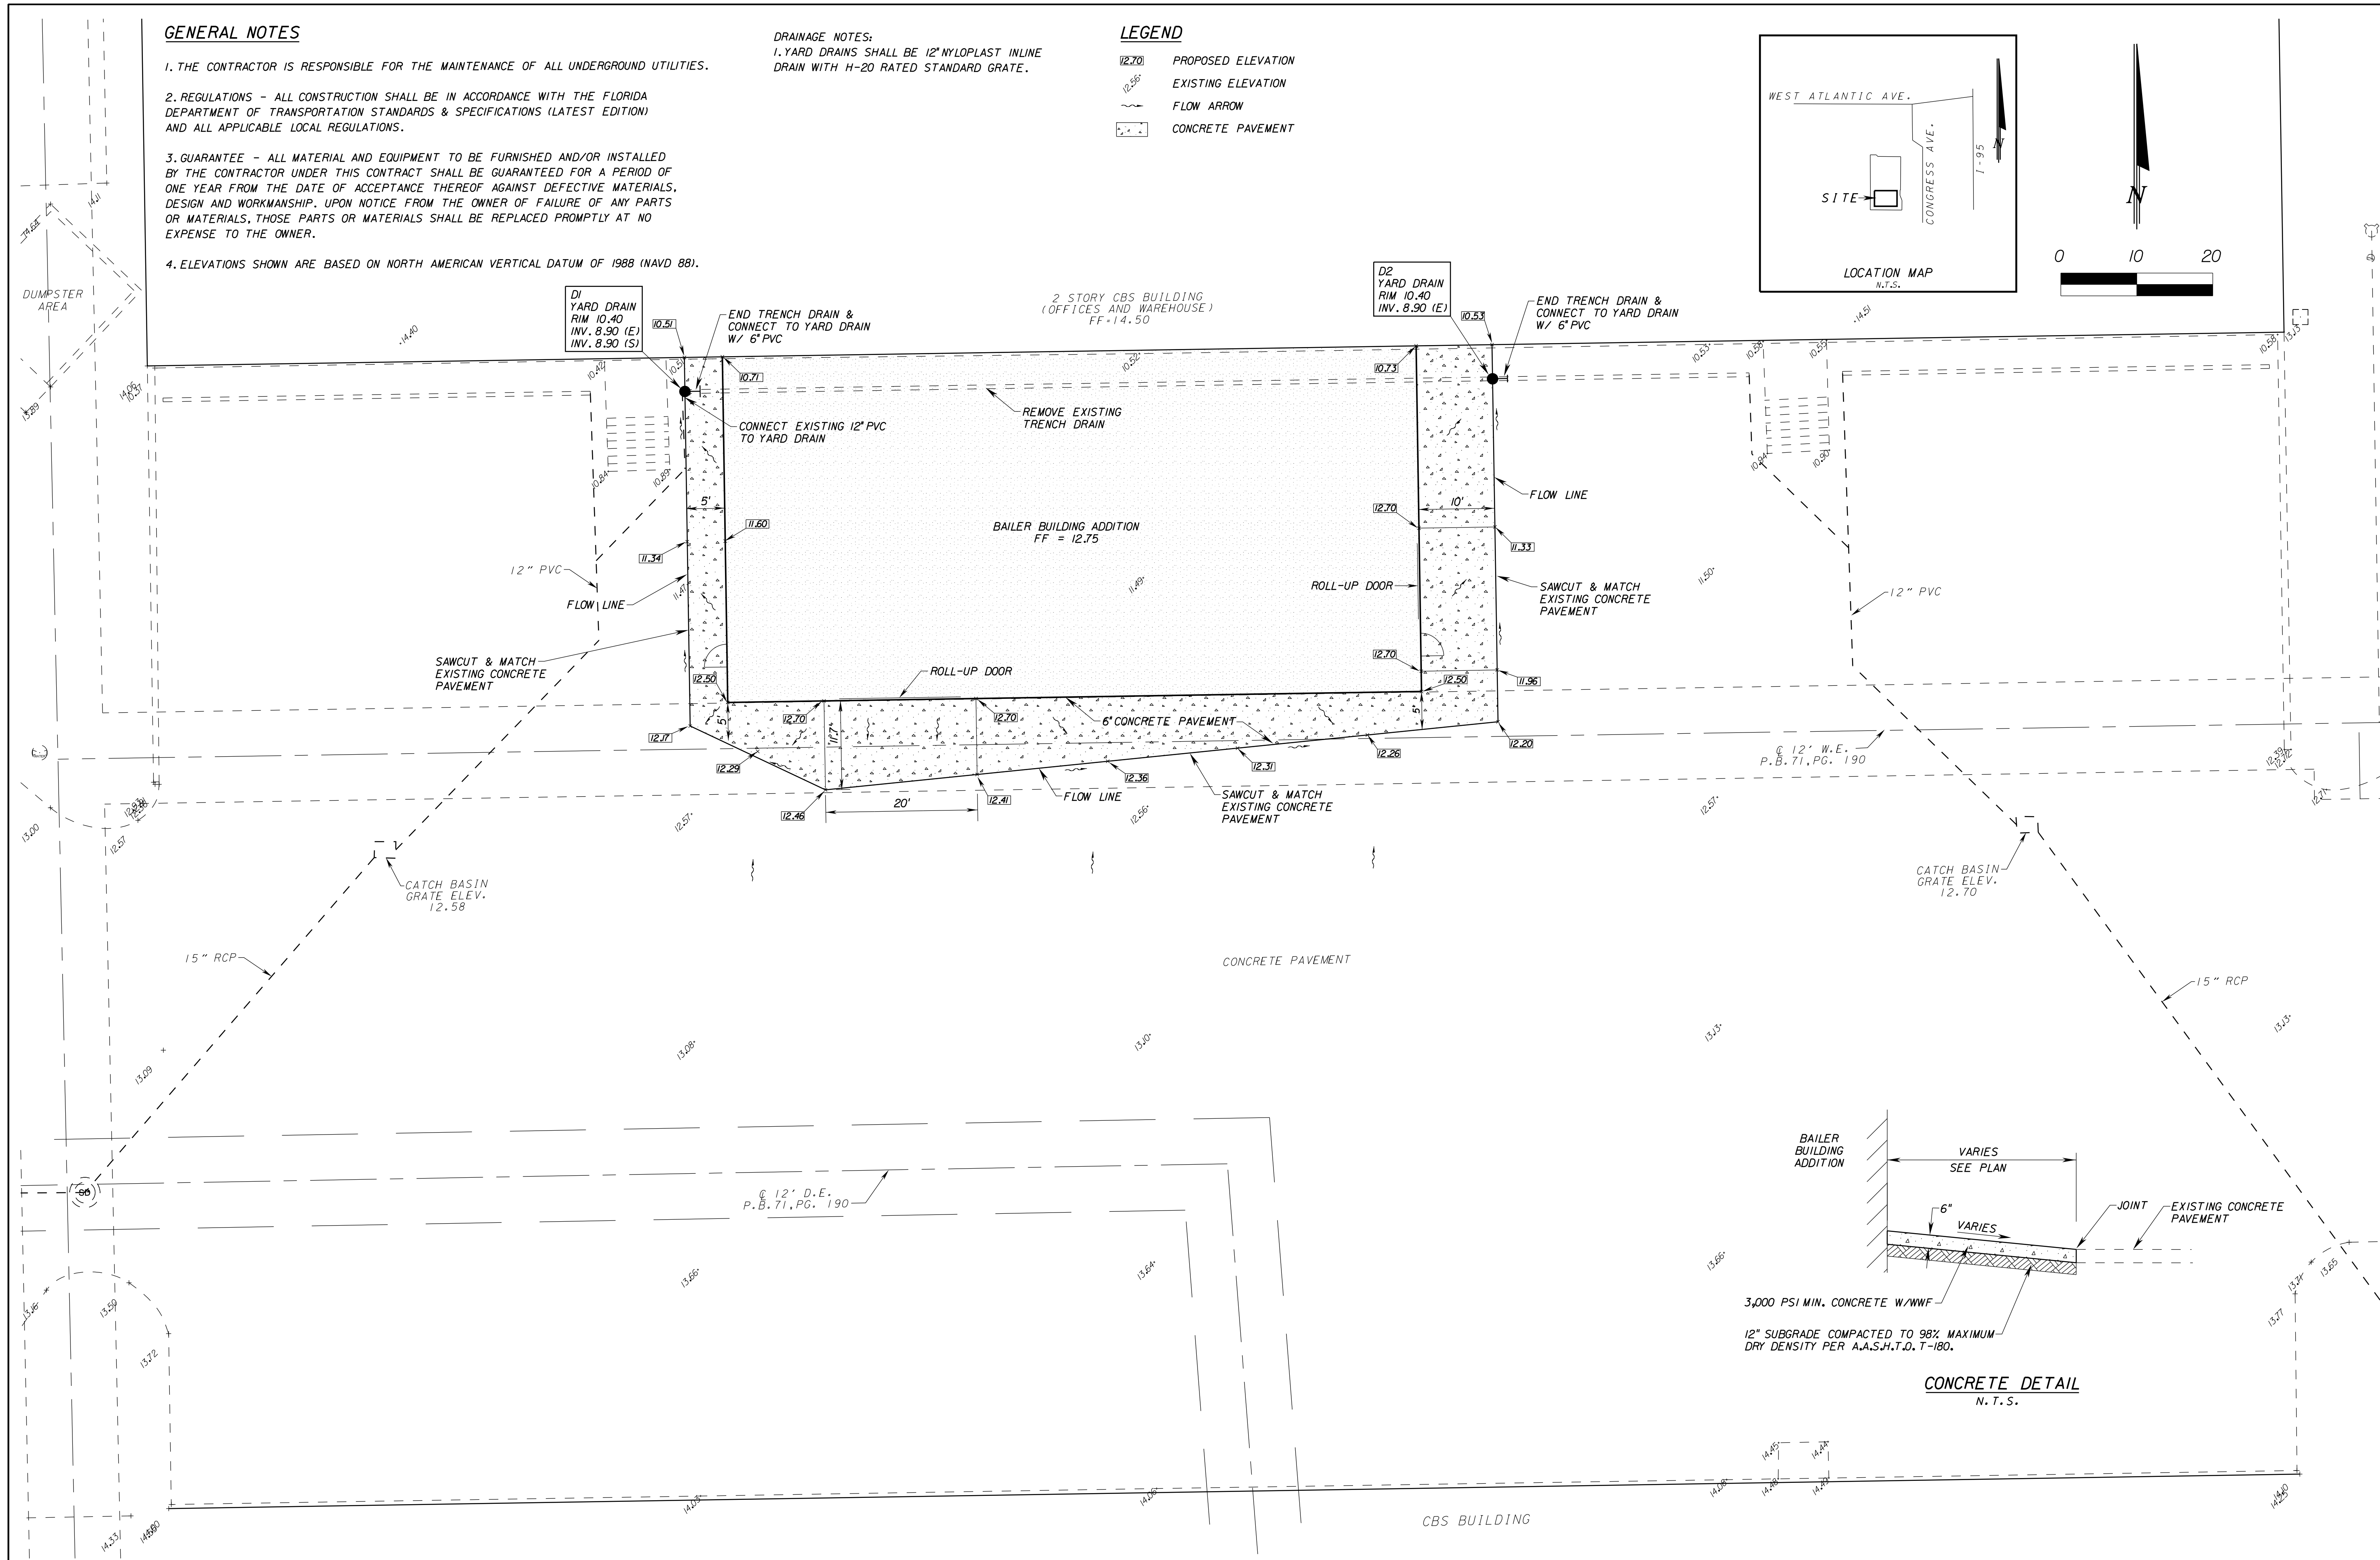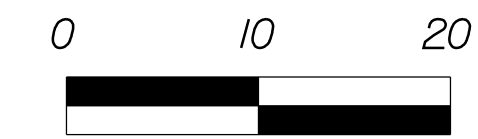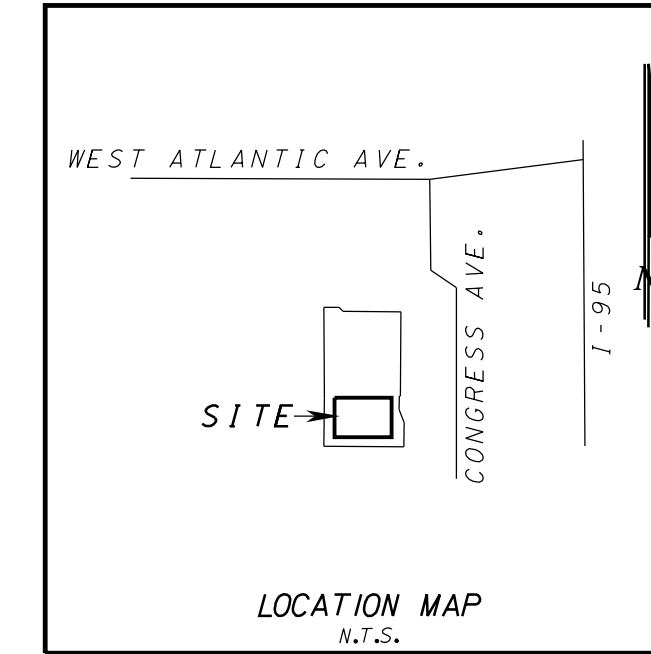

REVISIONS			
NO.	DATE	BY	DESCRIPTION

STEVEN M. PAWLYK, P.E.
 F.L. REG. NO. 61800
 DATE _____

S. SEXTON ENGINEERING ASSOCIATES, INC.
 CONSULTING ENGINEERS AND SURVEYORS
 110 PONCE DE LEON STREET, SUITE 100
 ROYAL PALM BEACH, FLORIDA 33411
 PHONE 561-792-3122 FAX 561-792-3168
 FL. REGISTRATIONS: LB0006837, EB 0007864

**PETMEDS BAILER BUILDING
 DELRAY BEACH, FLORIDA**

PAVING & DRAINAGE PLAN

PROJ. NO. 1765 DATE 06/17/2016
 SCALE 1"=10' SHEET 1 OF 1