

**CONSULTANTS:**

ELECTRICAL, MECHANICAL,  
 PLUMBING:

AMERICAN UNITED ENGINEERS  
 4508 SW 24TH STREET  
 FORT LAUDERDALE, FL 33317  
 PHONE: (954) 471-8657

**PROJECT:**

INTERIOR IMPROVEMENTS  
 950 NW 9th Court  
 Boca Raton, FL

**CONSTRUCTION DOCUMENTS  
 PROGRESS - PRICING SET**


PROJECT NUMBER: 2016.06  
 DATE: 7-18-2016  
 CAD FILE NO: 1608 SHEET A1.0.dwg

**ADDENDA/REVISIONS**

△	
△	
SEAL:

**1** NEW REFLECTED CEILING PLAN  
 A3.0 SCALE: 1/4" = 1'-0"

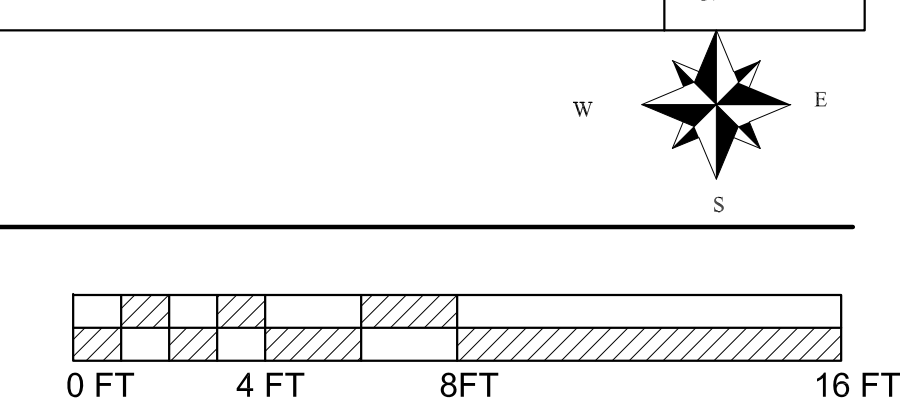

CYNTHIA C. SPRAY, AIA AR-94167  
 DRAWING TITLE:  
 NEW REFLECTED  
 CEILING PLAN

DRAWING NO: **A3.0**