



INTERIOR ELEVATIONS

SCALE: 1/4" = 1'-0" **1**



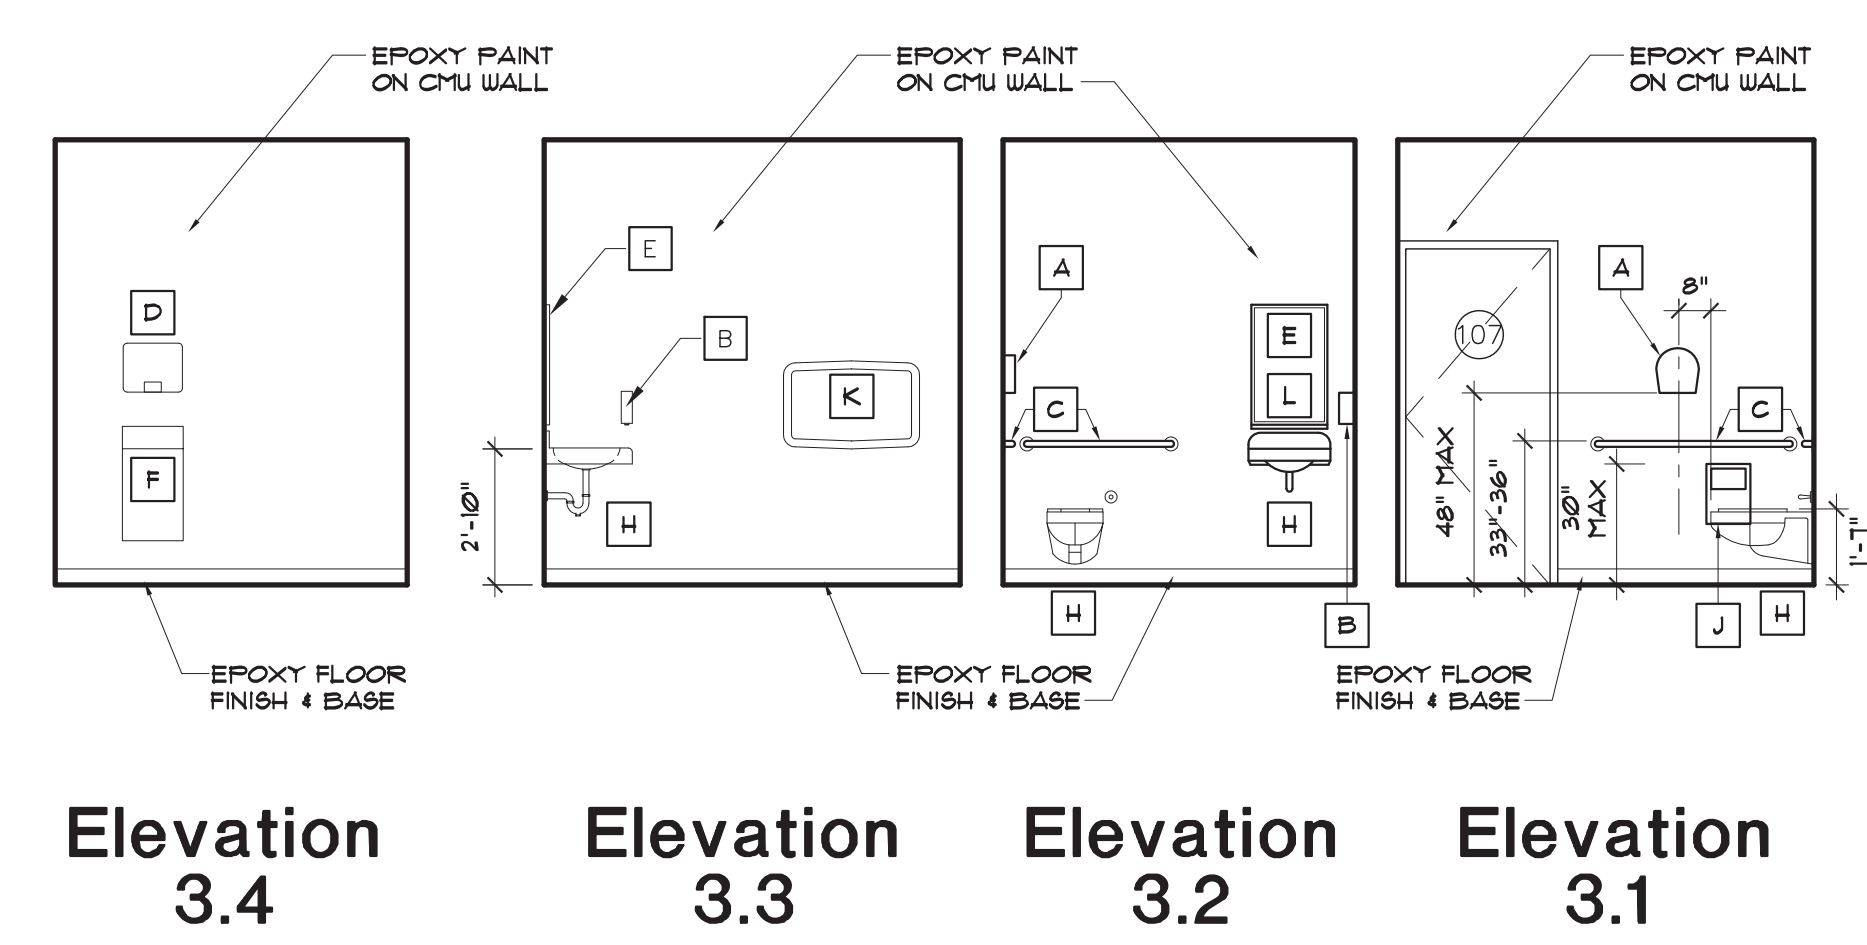


INTERIOR ELEVATIONS

SCALE: 1/4" = 1'-0" **3** **BASE DETAIL** SCALE: 3" = 1'-0" **2**

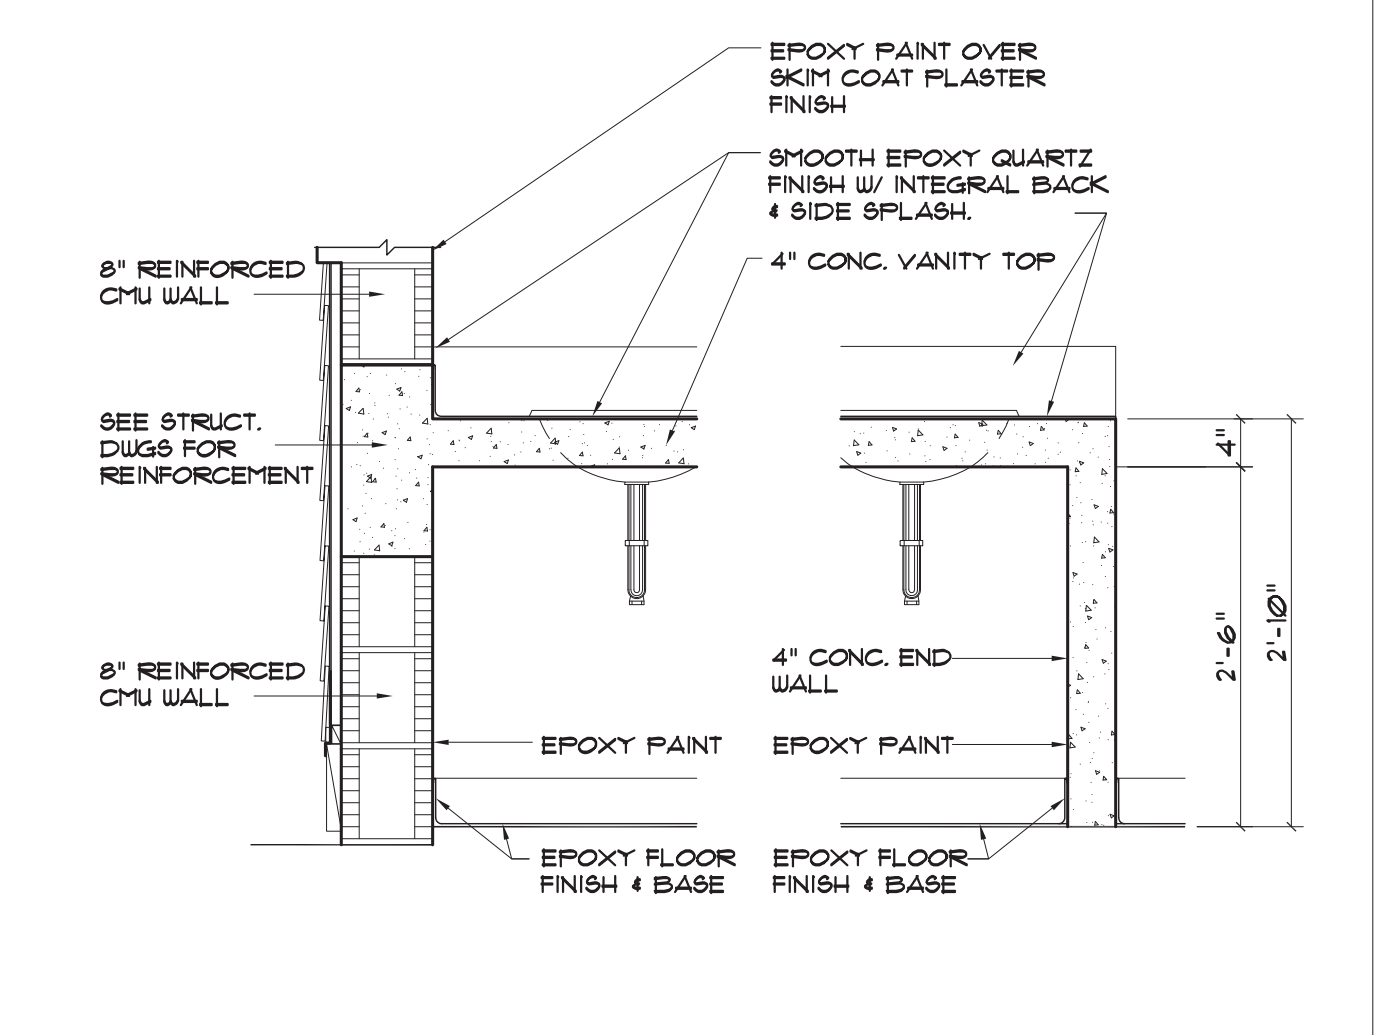

- NOTES:**
- ALL ACCESSORIES SHALL MEET PALM BEACH COUNTY STANDARDS. VERIFY WITH OWNER PRIOR TO BIDDING & FABRICATION.
 - THE FOLLOWING ITEMS WILL BE PROVIDED BY THE OWNER (PBC PARKS) AND INSTALLED BY THE GC - TOILET TISSUE DISPENSERS, SOAP DISPENSERS, SEAT COVER DISPENSERS, SANITARY NAPKIN DISPOSALS.
 - PROVIDE STAINLESS STEEL, ALL THREAD NUTS AND WASHERS FOR WALL HUNG TOILET HANGERS (TYP).
- A** GEORGIA PACIFIC MODEL 59009, 9" JUMBO TOILET PAPER DISPENSER 19" MIN. AFF. AT EACH H.C. W.C.
 - B** LITE & FOAMY, PART # 9757, WALL MOUNTED SOAP DISPENSER, TOP AT 50" AFF. AT LAV.
 - C** BOBRICK MODEL B-490 GRAB BARS, 36" & 42" GRAB BARS AT 33"-36" AFF.
 - D** BOBRICK MODEL B-700, SURFACE-MOUNTED, SURFACE MOUNTED HAND DRYER (INSTALLED 48" AFF.)
 - E** BOBRICK MODEL B-1556 S.S. FRAMELESS MIRROR, BOTT. OF REFLECTIVE SURFACE 40" MAX. AFF. AT EA. LAV, 18"X30" • ADA STALL, 24"X36" • LAV.
 - F** BOBRICK MODEL B-277, CONTURA SERIES SURFACE-MOUNTED WASTE RECEPTACLE 36" AFF.
 - G** SOLID PLASTIC TOILET PARTITIONS - POLYMER RESIN - SEE SPECIFICATIONS.
 - H** PLUMBING FIXTURE, SEE PLUMB. DWGS. CONTRACTOR TO PROVIDE AND INSTALL ALL RELATED ACCESSORIES, TYP.
 - I** BOBRICK MODEL B-671, ROBE HOOK (INSTALLED AT ALL TOILET STALLS, 60" AFF.) (ADA STALLS • 40")
 - J** BOBRICK MODEL B-254 SURFACE MOUNTED SANITARY NAPKIN DISPOSAL AT 30" AFF. MAX.
 - K** KOALA KARE MODEL KB200-00 WALL MOUNTED BABY CHANGING STATION - CHANGING SURFACE TO BE AT 34" AFF. WHEN OPEN.
 - L** S.S. SHELF AT BOTTOM OF MIRROR IN ADA STALL ONLY

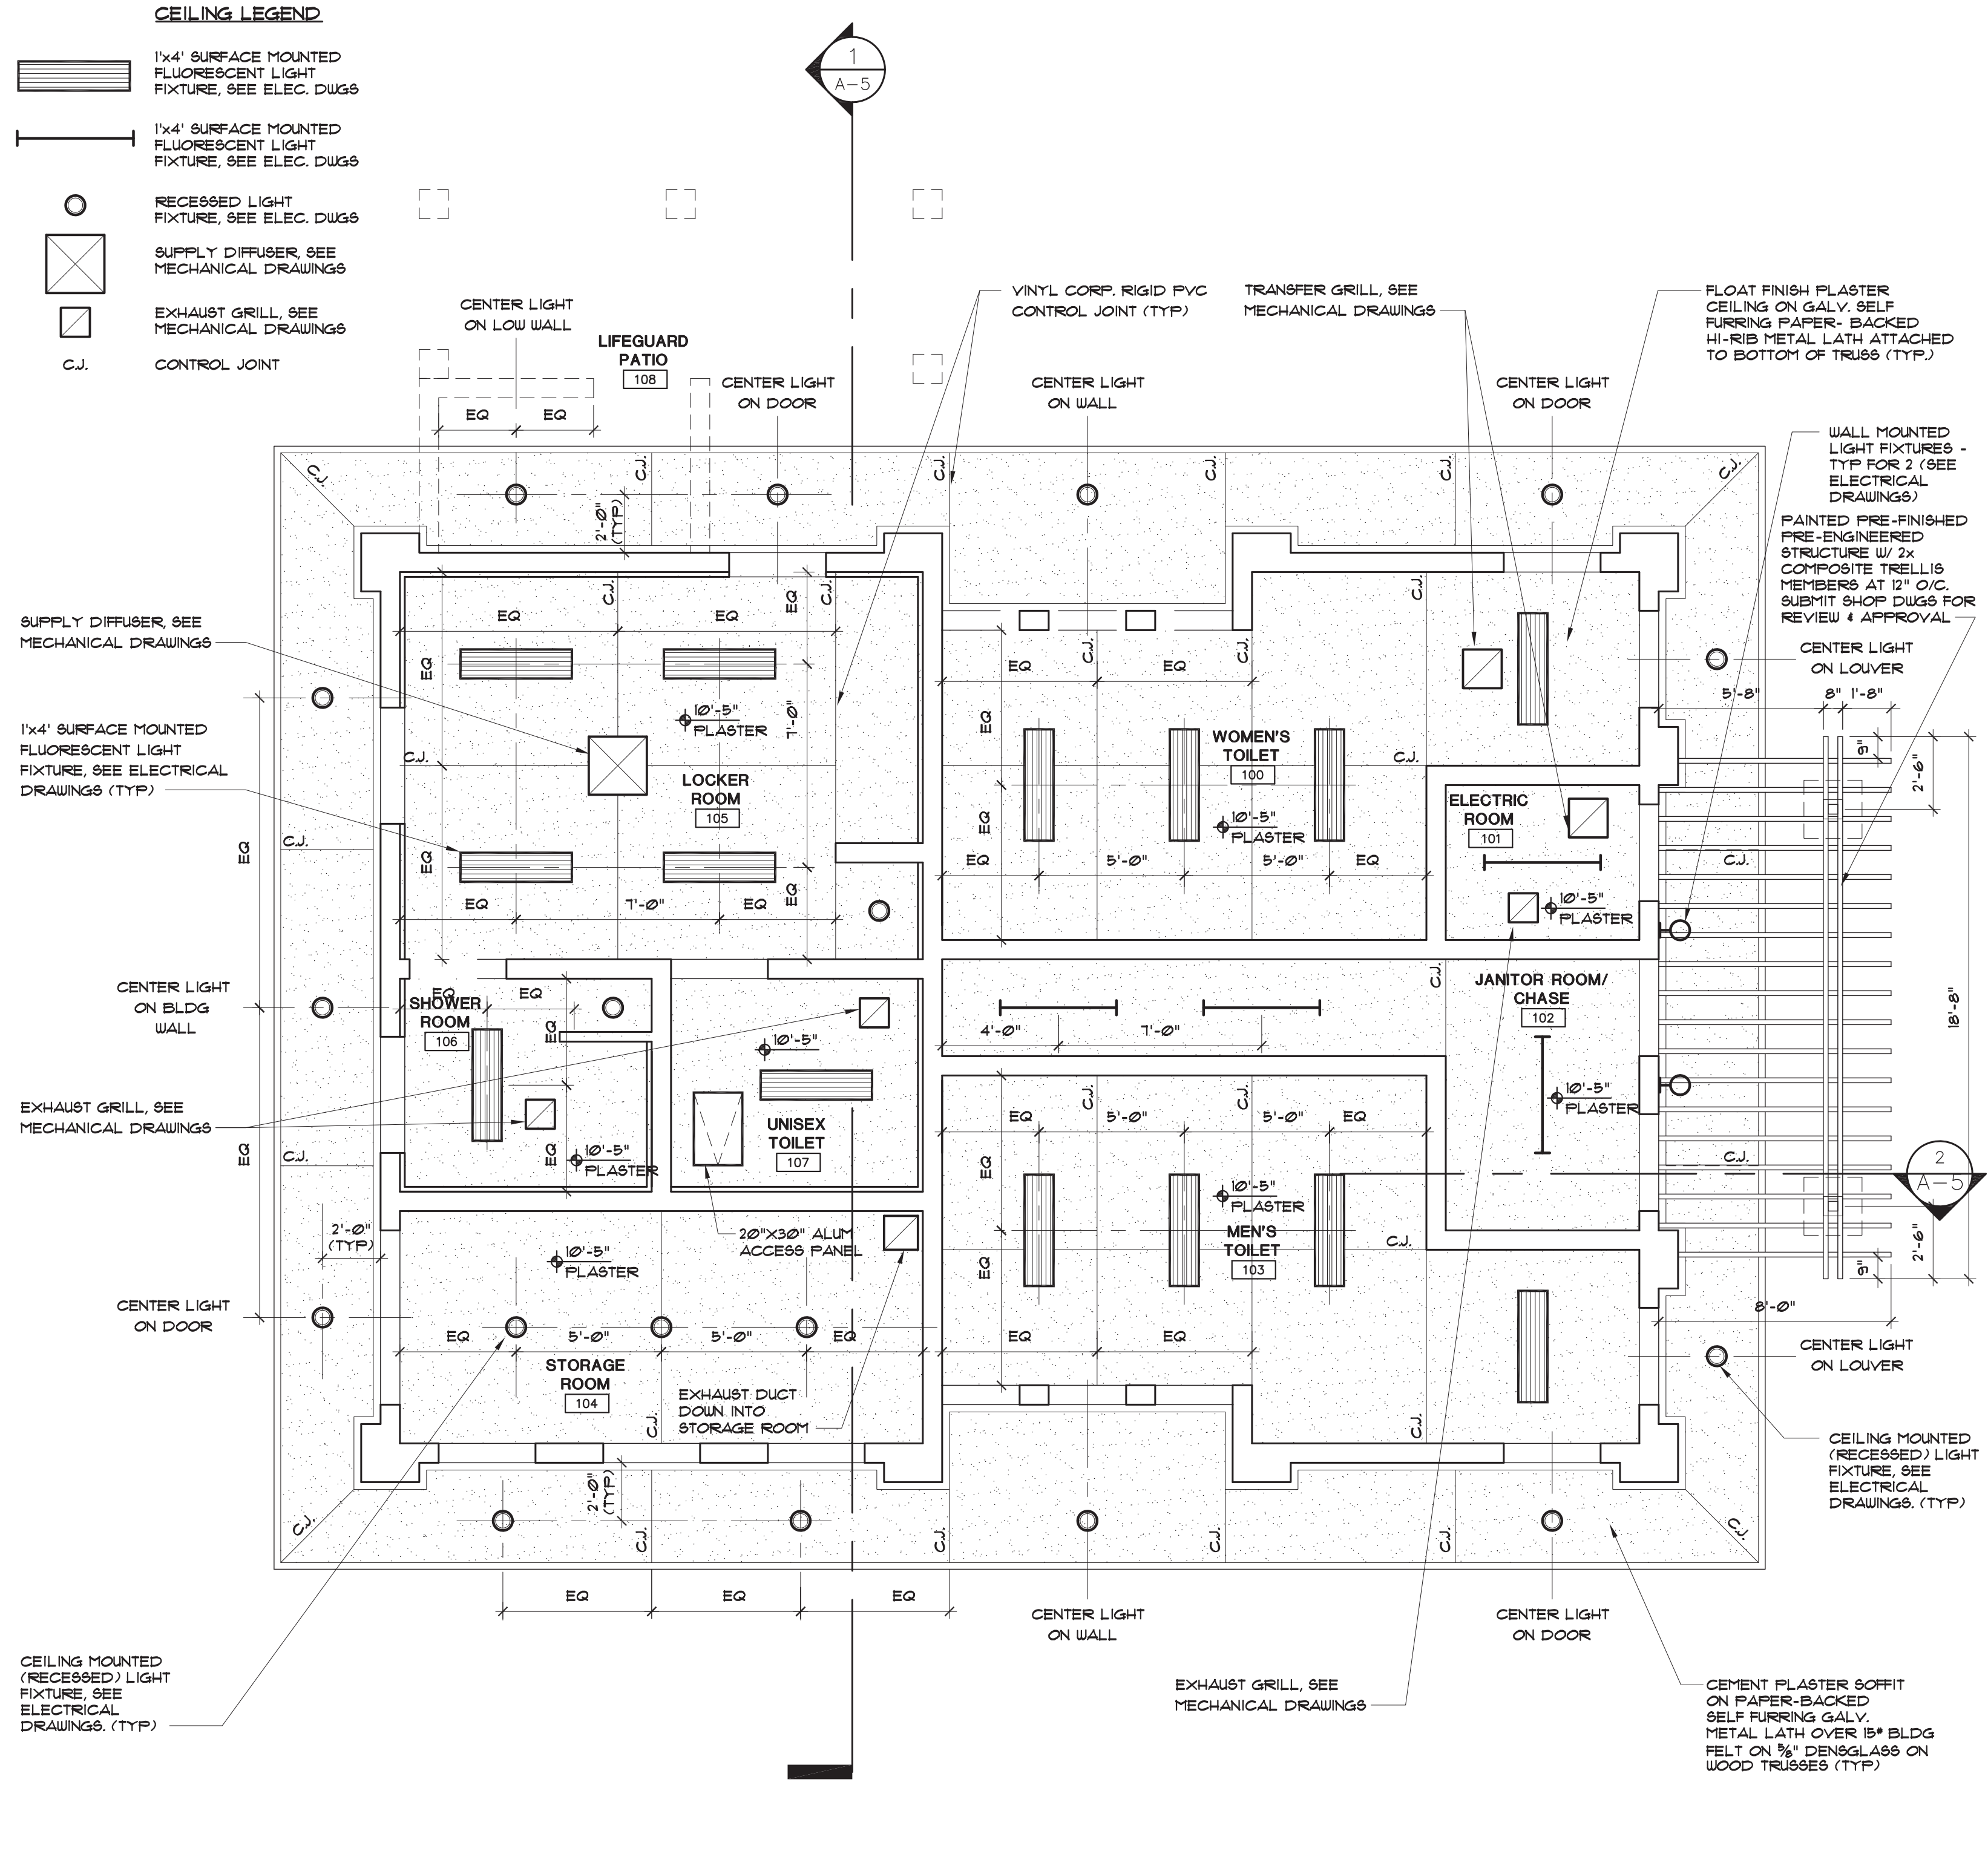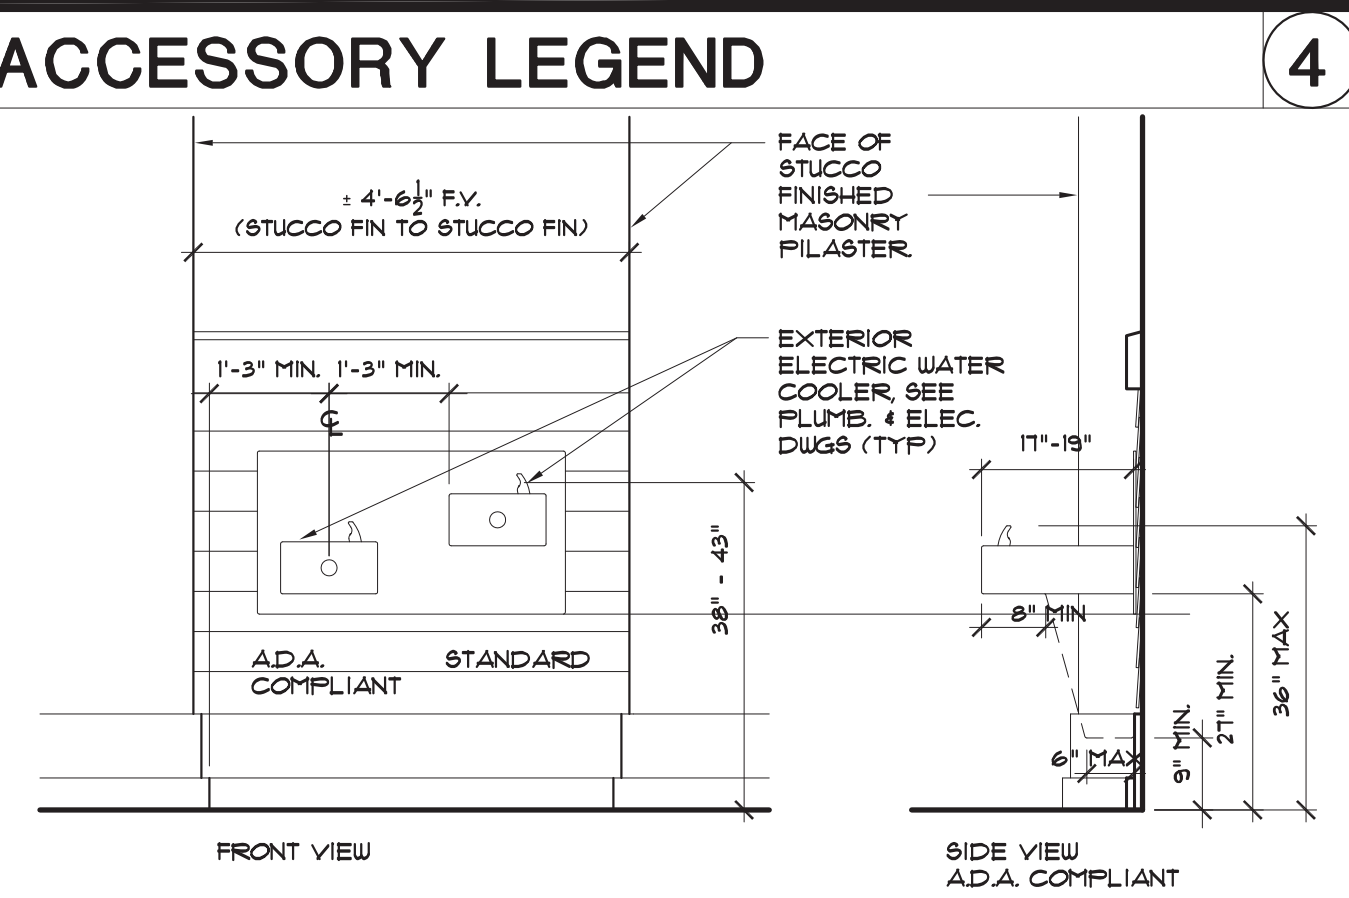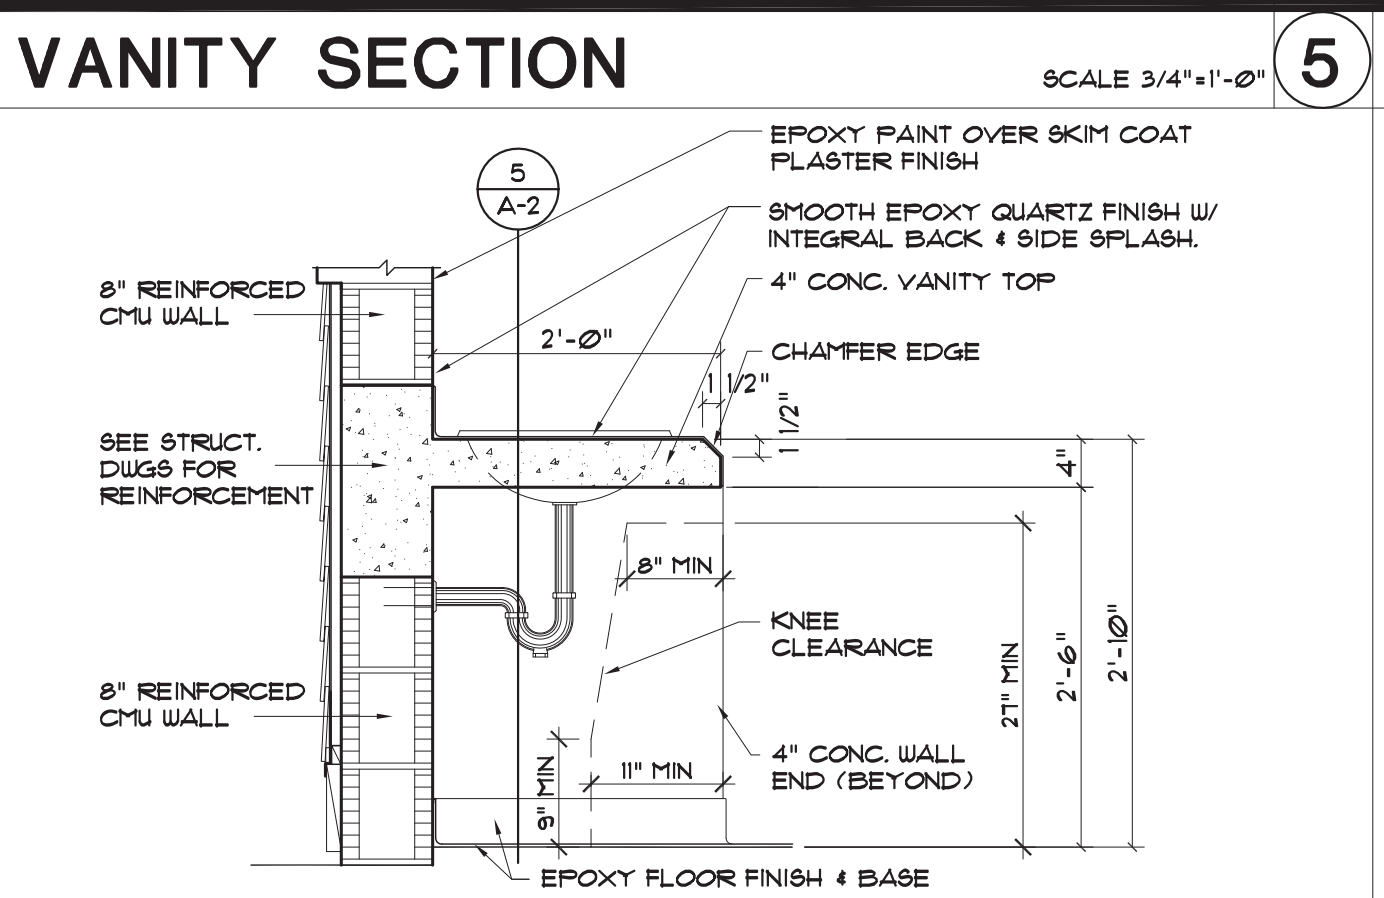

COLOME' & Associates, Inc.
 AA 0003439
 530 24TH STREET
 WEST PALM BEACH
 FLORIDA 33407
 (561) 833-9147
 ARCHITECT: ELIZABETH A. COLOME
 REG. NUMBER: AR. 004839

P. B. C.
 R.G. KREUSLER PARK
 RESTROOM BUILDING
 AND ENTRY DRIVE
 MODIFICATIONS
 PBC NO 14204
 2886 SOUTH OCEAN BLVD.

LAKE WORTH
 FLORIDA
 PROJECT NO.
 201402

SHEET TITLE:
**REFLECTED
 CEILING PLAN
 AND INTERIOR
 ELEVATIONS**

REVISIONS:

DATE
 11/20/15
 DRAWN BY:
 DM
 CHECKED BY:
 EAC

SHEET
 NUMBER

A-2