


THE FIRE ALARM SYSTEM SHALL BE BY A LICENSED CONTRACTOR UNDER A SEPARATE PERMIT, INCLUDING SHOP DRAWINGS AND CALCULATIONS.

SYMBOL LEGEND	
	HORN WITH STROBE LIGHT, MOUNTED, 400"
	STROBE LIGHT, MOUNTED, 400"
	FIRE ALARM MAN. FULL STATION 441"
	INDICATES ELECTRICAL PANEL

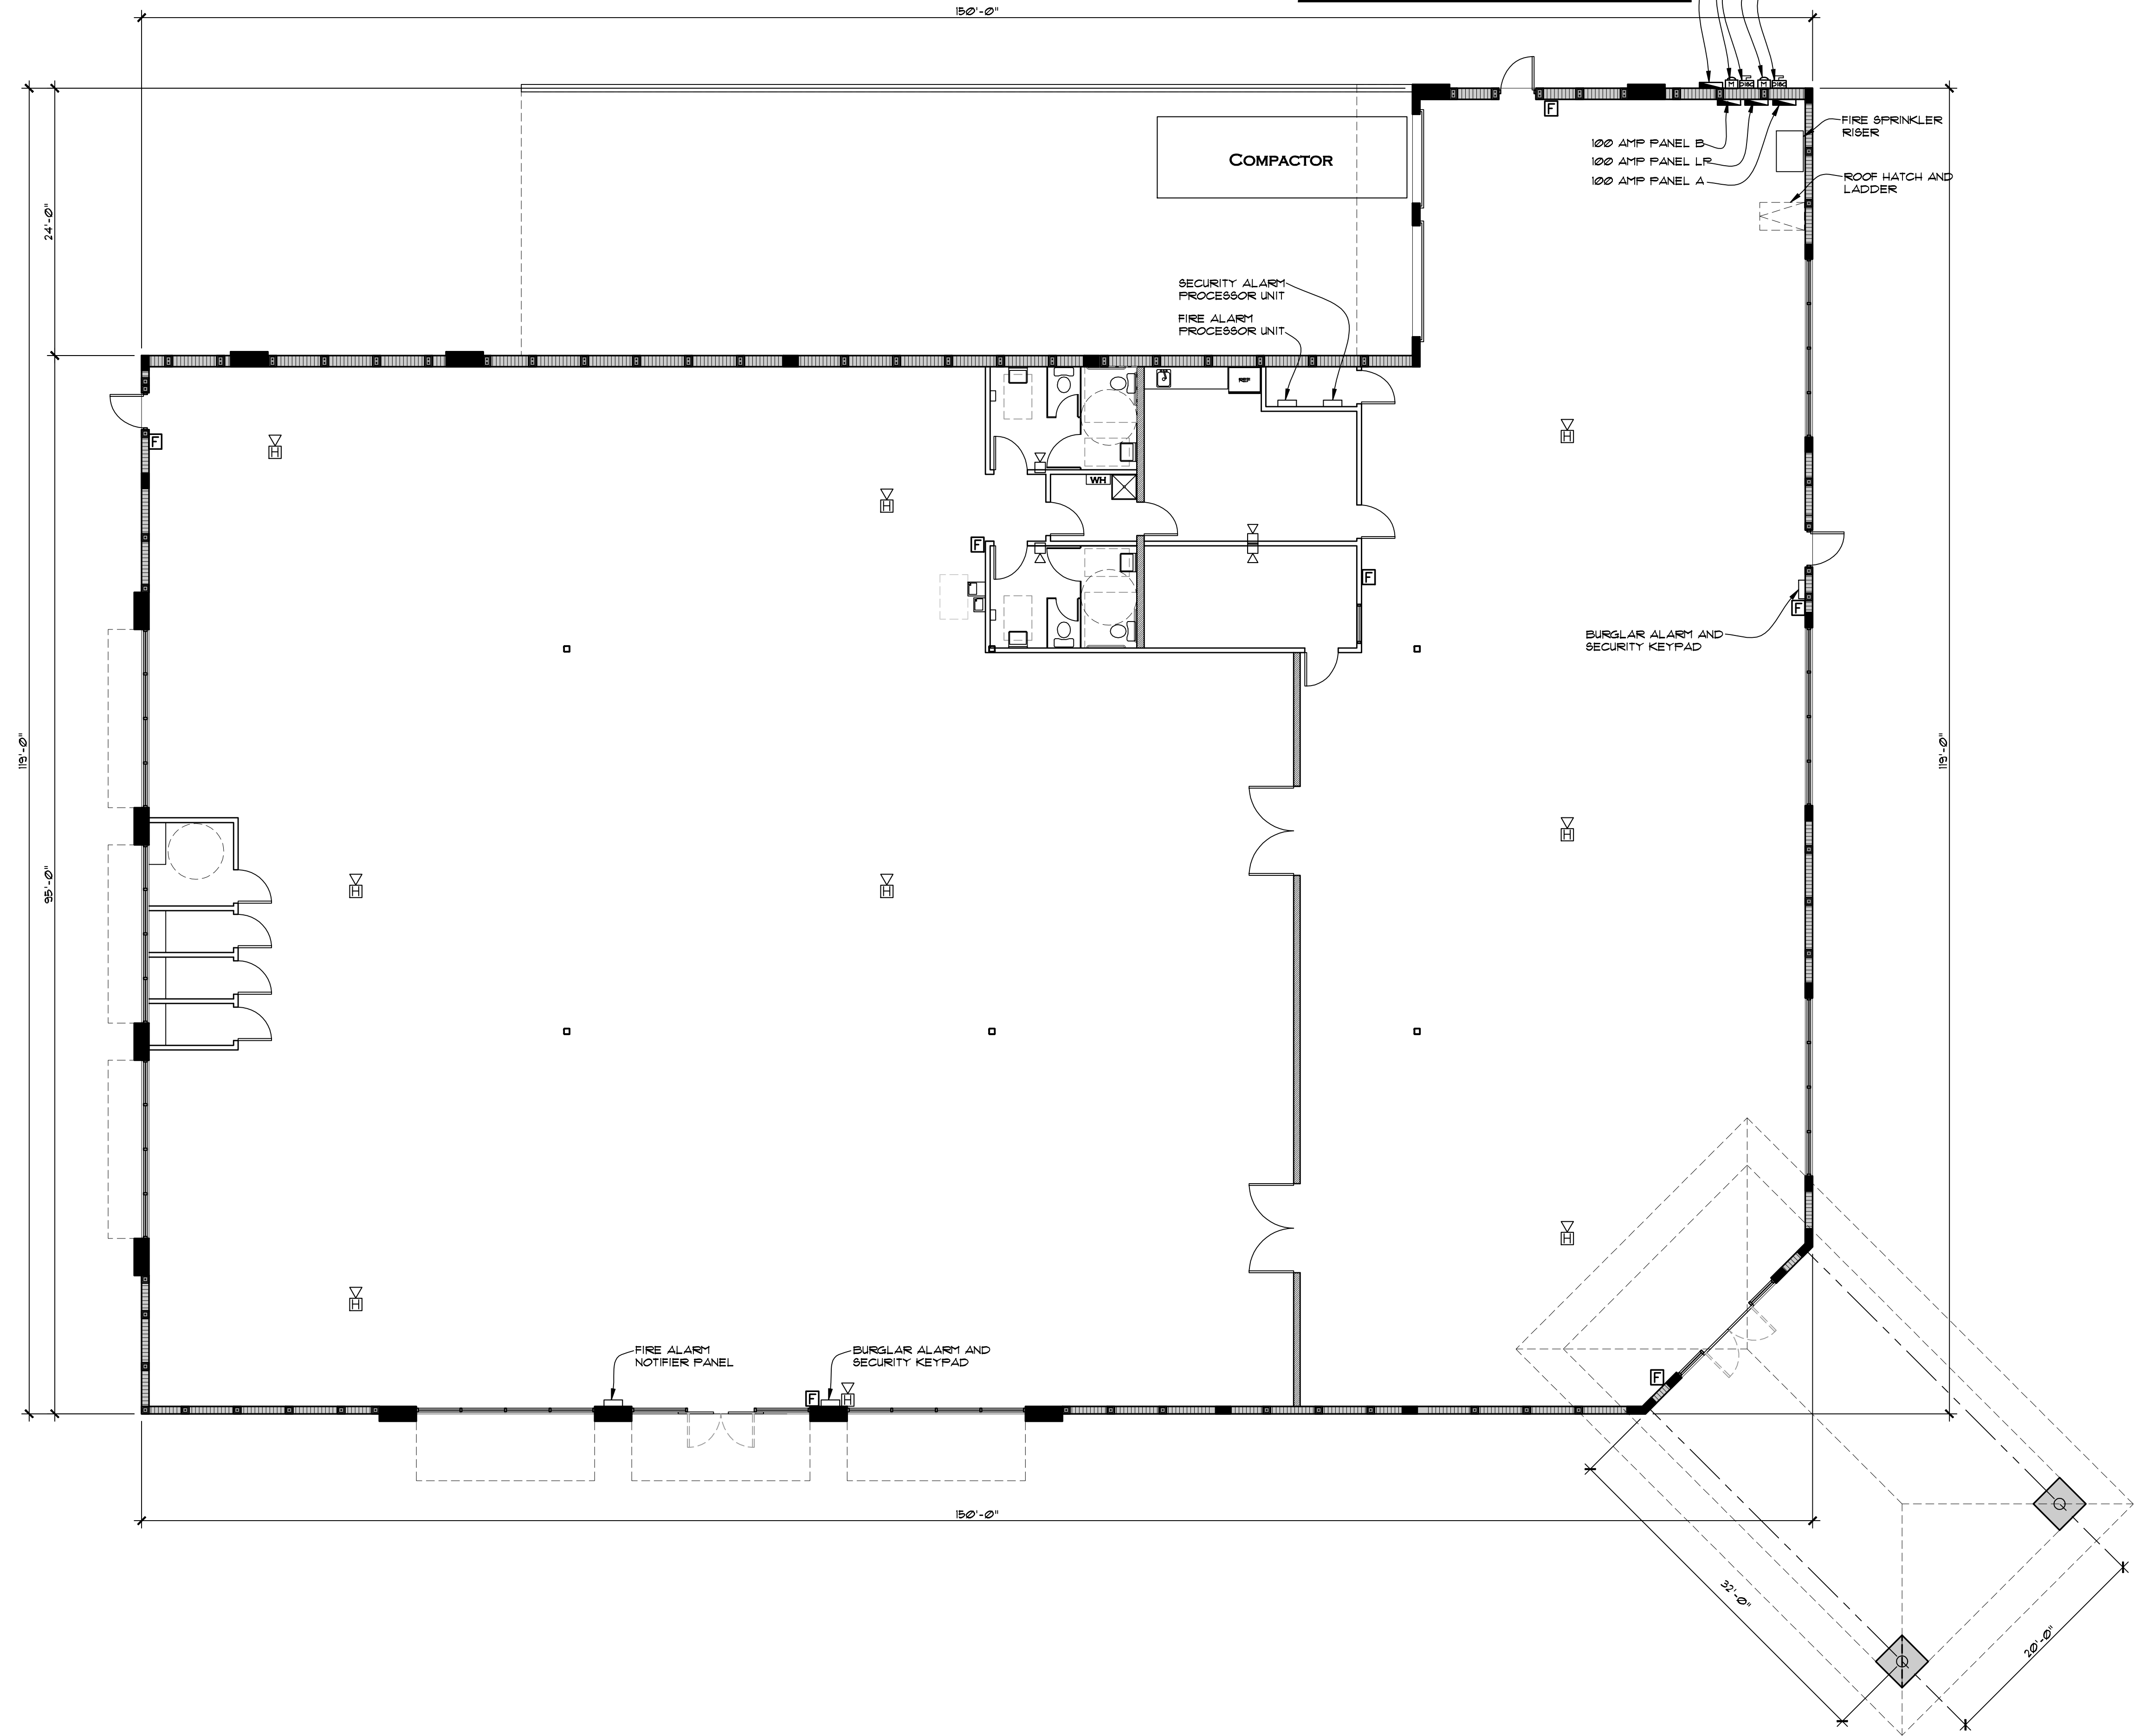

Revisions:	
1	
2	
3	
4	
5	

Project Number  
**160412**

Project Name  
**1066 U.S. HIGHWAY 1  
NEW RETAIL BUILDING - GOODWILL  
1066 U.S. HIGHWAY 1  
VERO BEACH, FLORIDA**


Project Name  
**NEW RETAIL BUILDING**

**STEPHEN BRASGALLA, ARCHITECT**  
STATE OF FLORIDA  
REGISTRATION No. AR12239  
6991 WEST BROWARD BOULEVARD  
SUITE 100  
PLANTATION, FLORIDA 33317  
TELEPHONE 954.614.3801  
TELEFAX 954.208.0800  
ARCHITECT @ DESIGN23.NET

**AS ISSUED FOR PERMIT 7-29-16 (NOT FOR CONSTRUCTION)**

Drawn By: RSS	Checked By: STB
Scale: SHOWN	Date: 7-29-16
Project Number <b>160412</b>	
Sheet: <b>FA-1</b>	

**FIRE ALARM PLAN**  
SCALE: 1/8" = 1'-0"

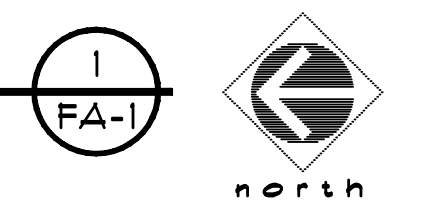

**FA - 1**