



The information contained herein is the property of Johnson, Levinson, Ragan, Davila, Inc. (JLRD) and is intended for copyright. Unauthorized use is prohibited. JLRD makes no warranty or guarantee as to the accuracy or completeness of the information contained herein, use without full verification is at the user's own risk. The user hereby represents, warrants, and agrees that use shall be confined to the specific conditions of the above conditions.

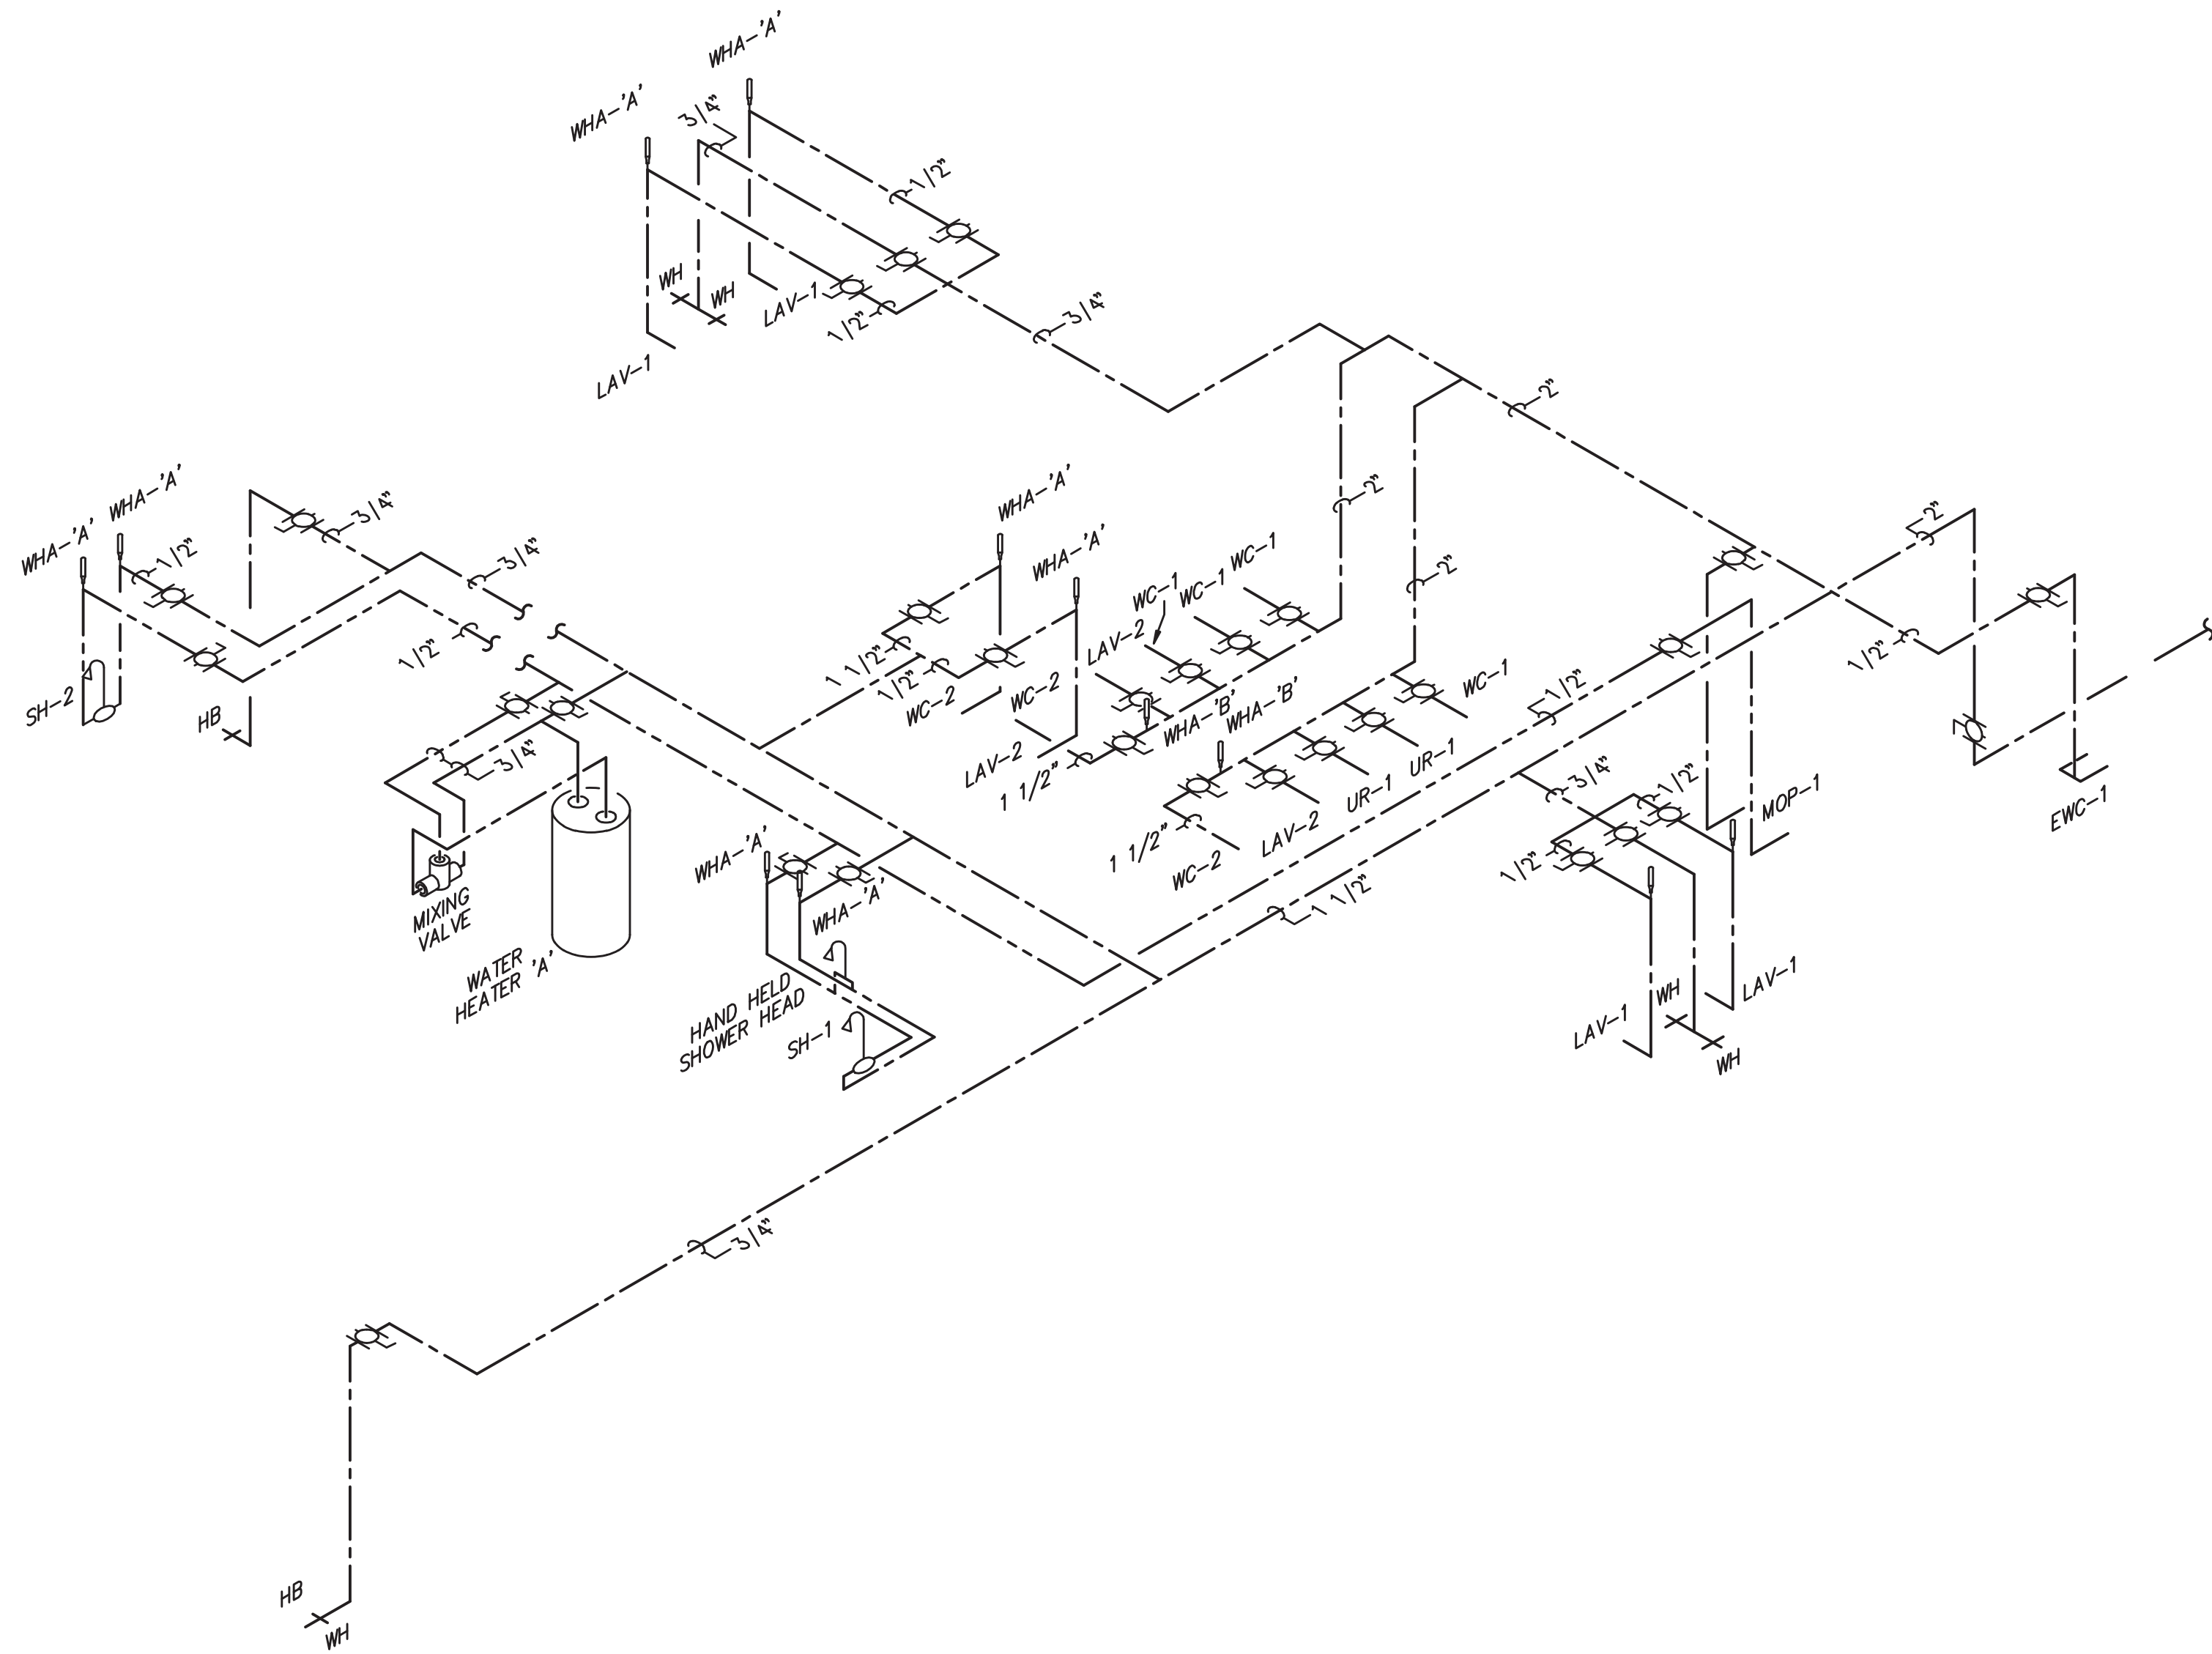


1 PLUMBING FLOOR PLAN - WATER RISER DIAGRAM
 P-3 SCALE: 1/4"=1'-0"

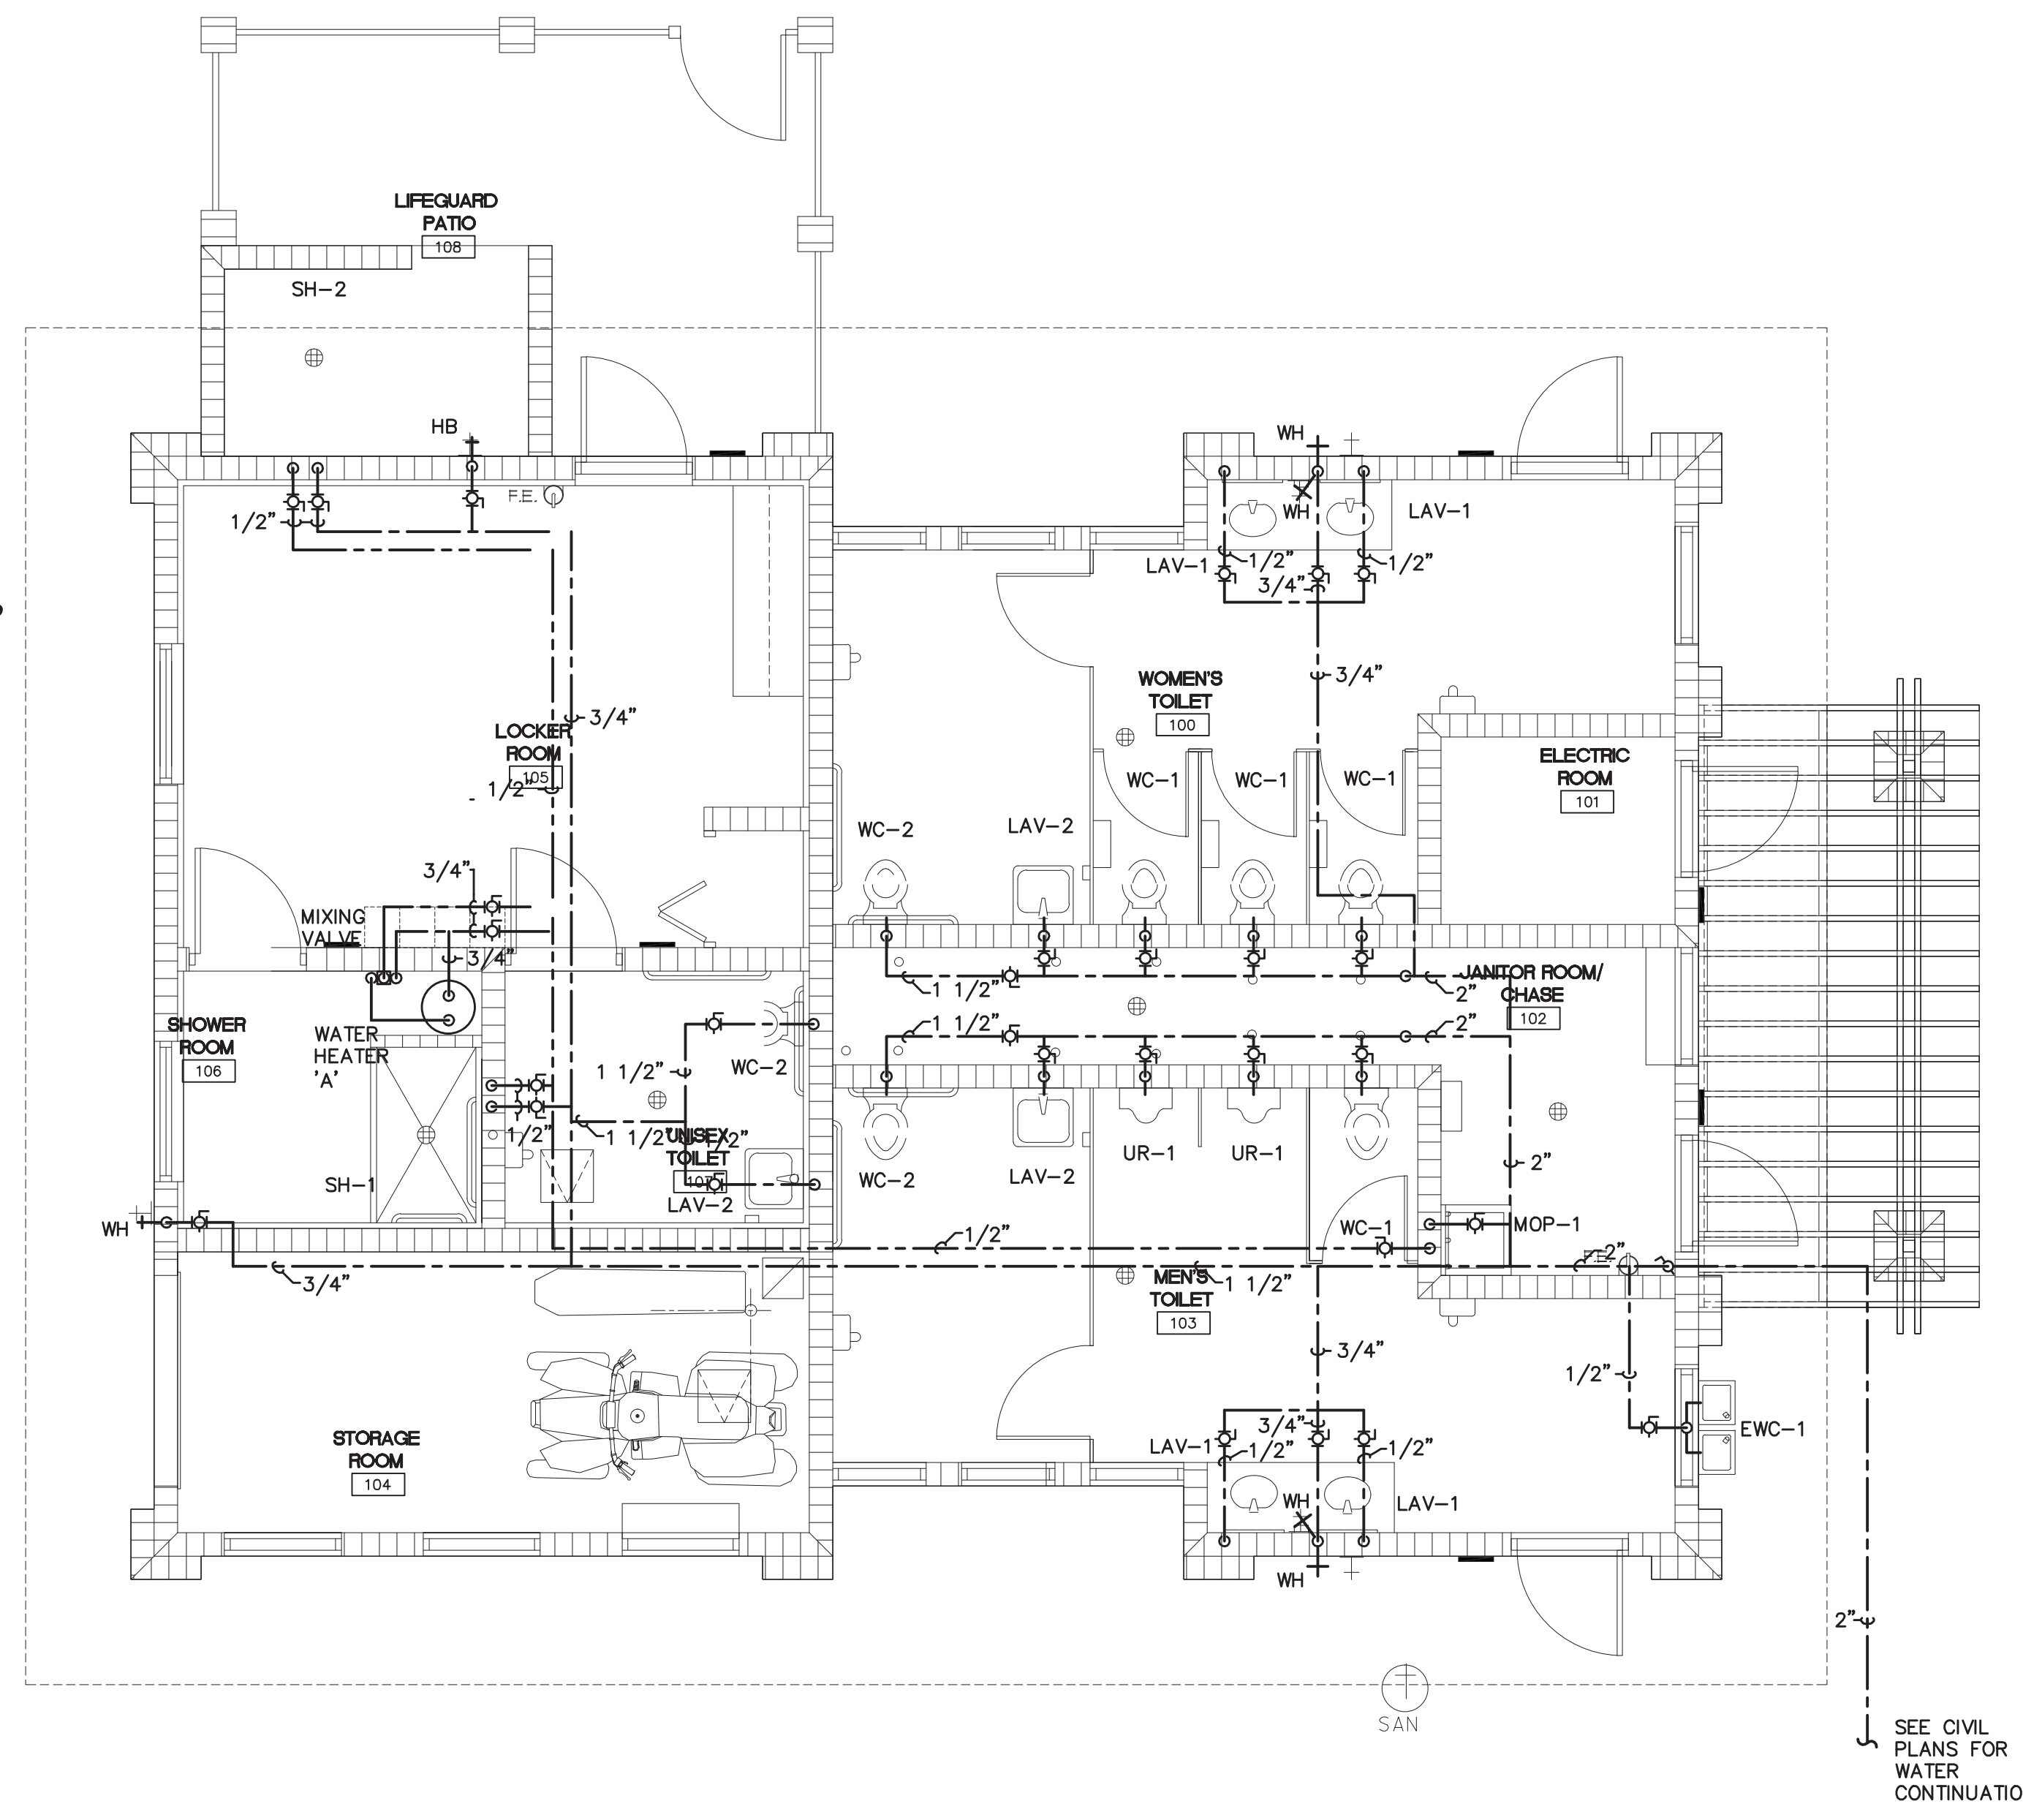


1 PLUMBING FLOOR PLAN - WATER PLAN
 P-3 SCALE: 1/4"=1'-0"


SEE CIVIL PLANS FOR WATER CONTINUATION.

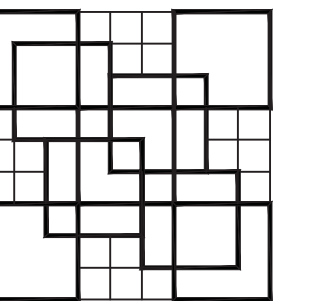

COLOME & Associates, Inc.
 AA 0003439
 8320 24TH STREET
 WEST PALM BEACH
 FLORIDA 33407
 (561) 833-9147

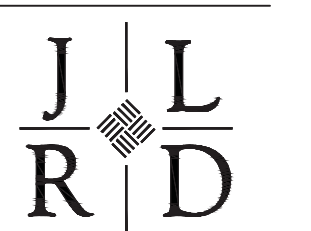


**JOHNSON, LEVINSON
 RAGAN, DAVILA, INC.**
 CONSULTING ENGINEERS
 180 CONVENT ROAD, SUITE 100
 WEST PALM BEACH, FLORIDA 33401
 (561) 689-2313 (661) 689-2302 Fax
 www.jlr.com
 Certification Number 06599
 Michael P. Linden, P.E. #58094
 Charles C. Gableman, P.E. #51936

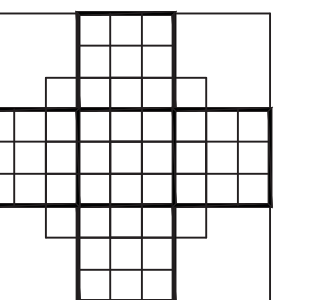

P.B.C.
 R.Q. KREUBLER PARK
 RESTROOM BUILDING
 AND ENTRY DRIVE
 MODIFICATIONS
 PBC NO 14204
 2886 SOUTH OCEAN BLVD.

LAKE WORTH
 FLORIDA
 PROJECT NO.
 201402
 JLRD NO.
 115042

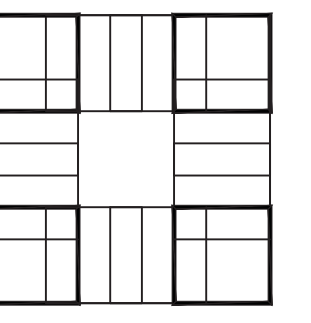

**SHEET TITLE:
 WATER PLAN AND
 RISER DIAGRAM**

REVISIONS:

DATE
 11/20/15
 DRAWN BY:
 RMT
 CHECKED BY:
 GBO

**SHEET
 NUMBER:
 P-3**