


THE FIRE ALARM SYSTEM SHALL BE BY A LICENSED CONTRACTOR UNDER A SEPARATE PERMIT, INCLUDING SHOP DRAWINGS AND CALCULATIONS.

SYMBOL LEGEND	
	HORN WITH STROBE LIGHT, MOUNTED, 400"
	STROBE LIGHT, MOUNTED, 400"
	FIRE ALARM MAN. FULL STATION 441"
	INDICATES ELECTRICAL PANEL

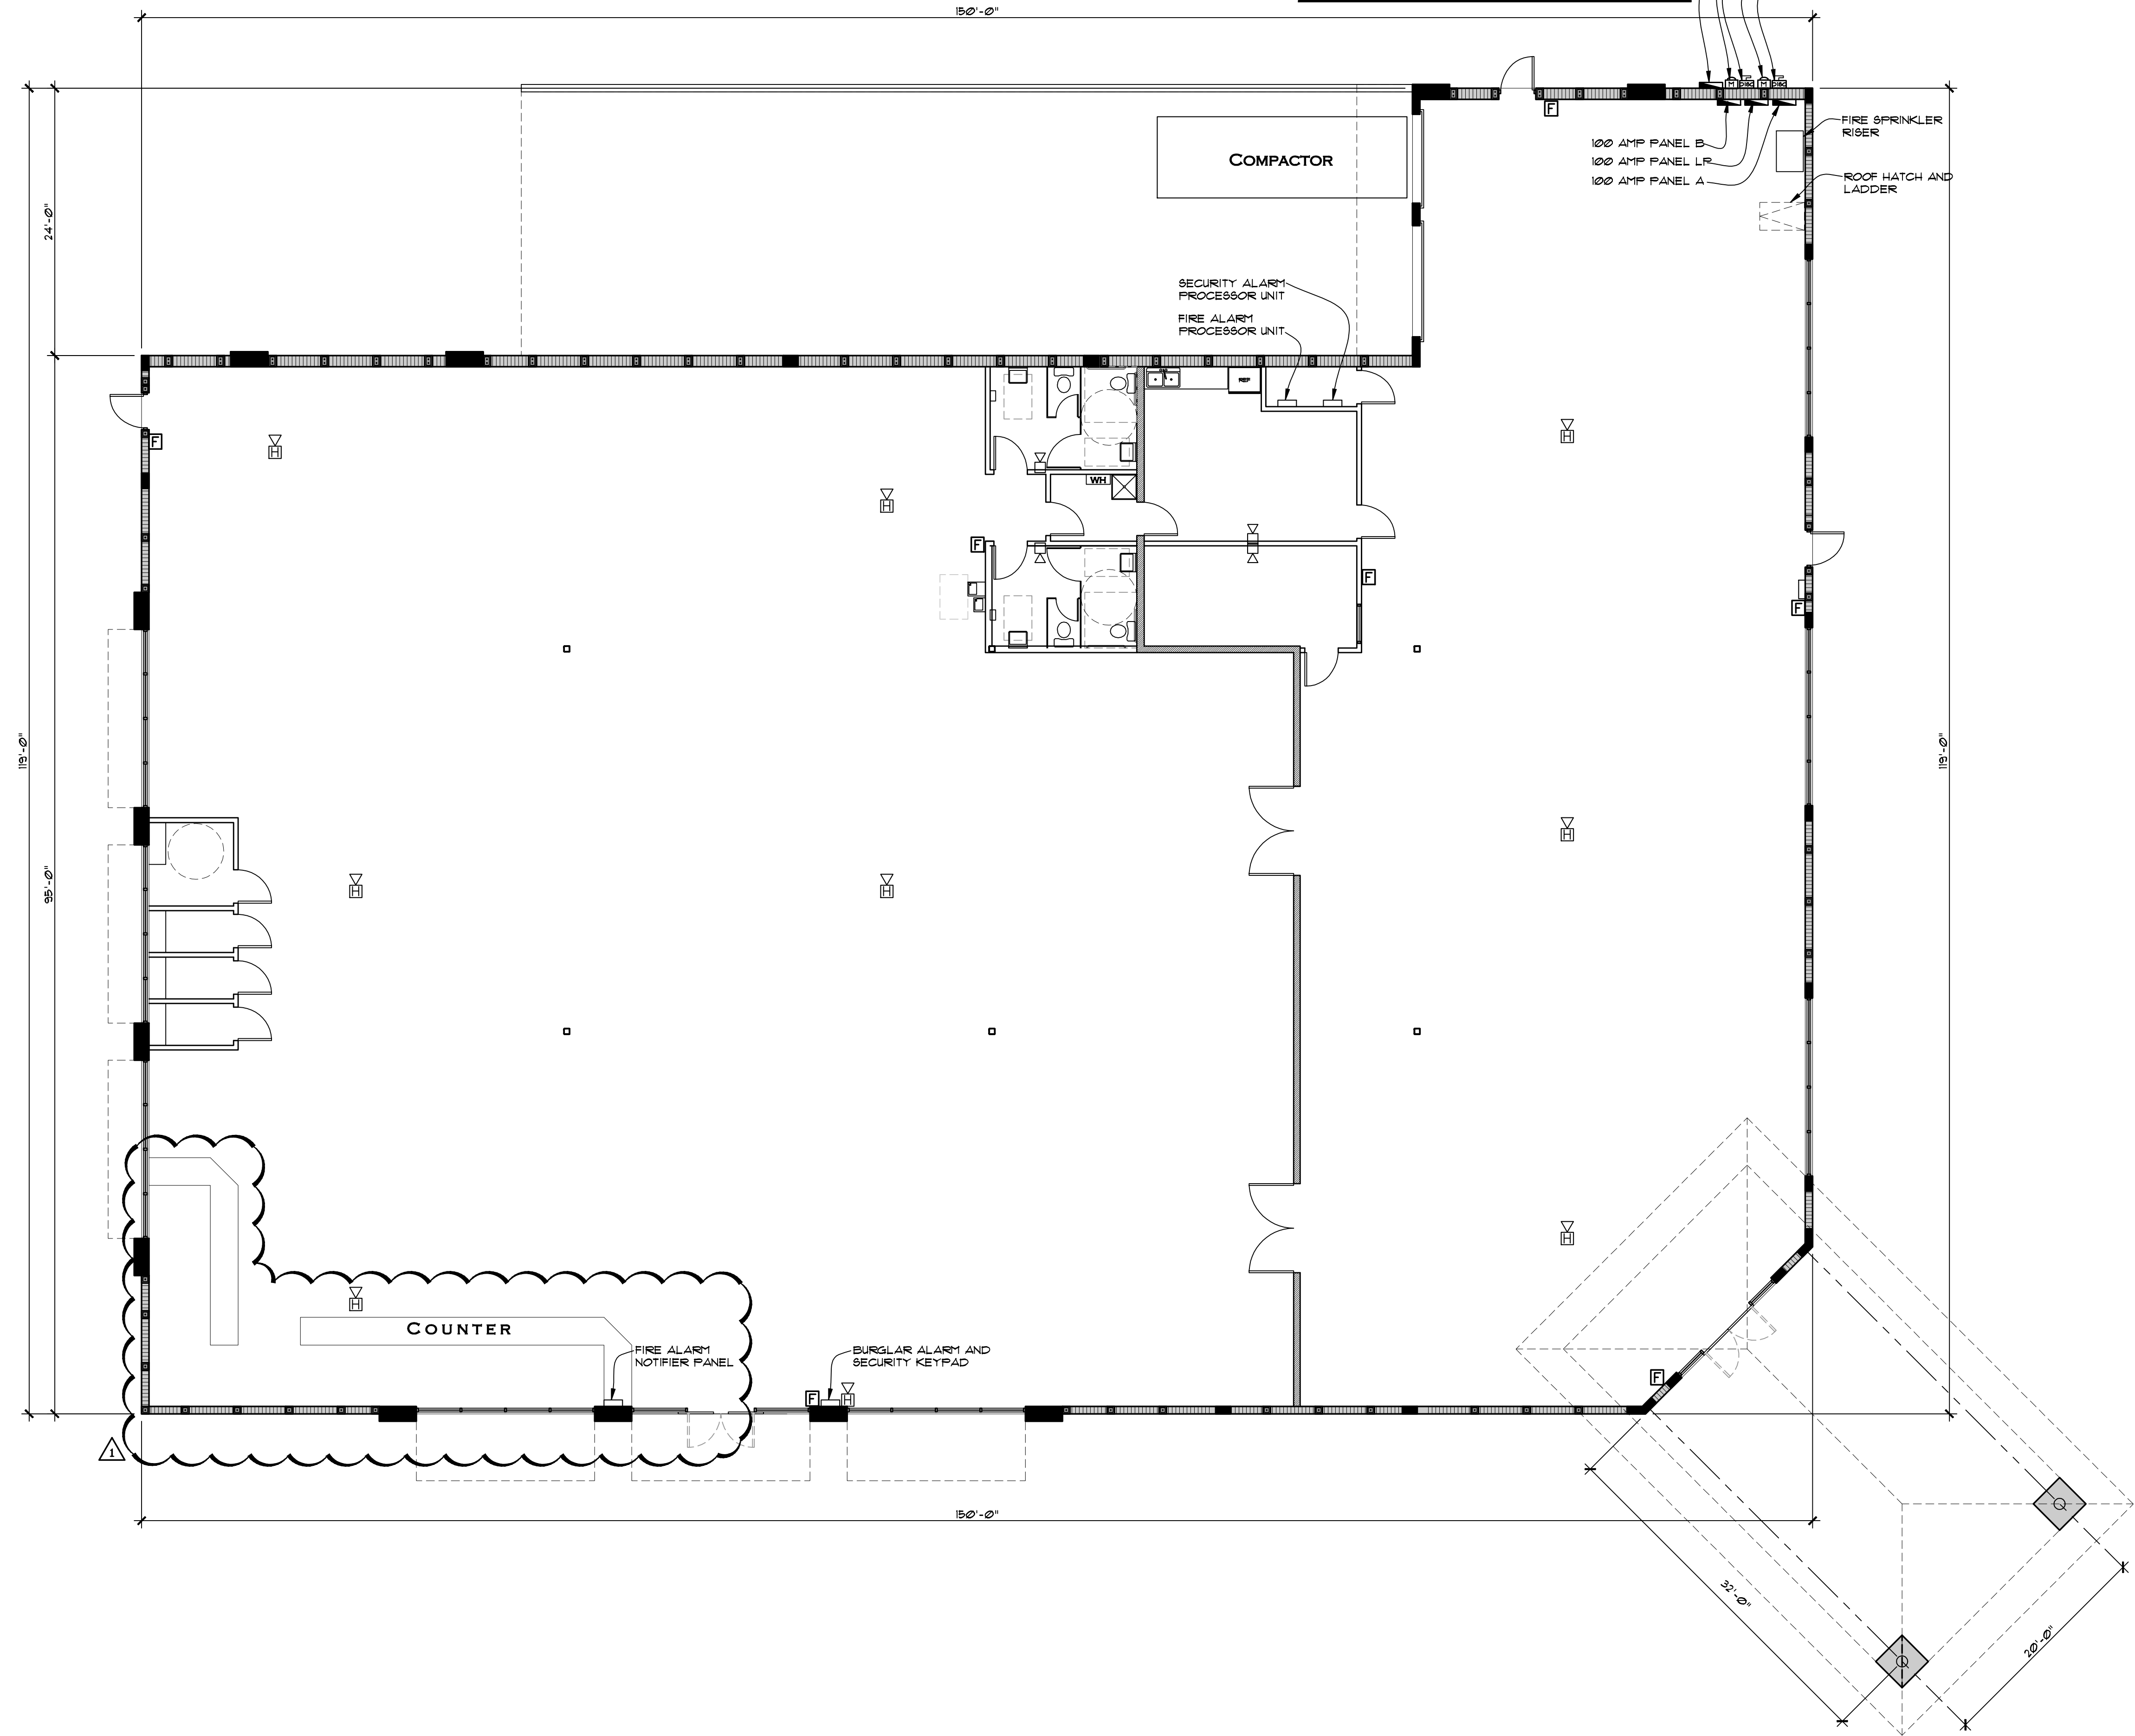

Revisions:	
1	9-19-16 OWNER REVISION
2	
3	
4	
5	

Project Number
160412

Project Name
**1066 U.S. HIGHWAY 1
NEW RETAIL BUILDING - GOODWILL
1066 U.S. HIGHWAY 1
VERO BEACH, FLORIDA**

Project Name
NEW RETAIL BUILDING

STEPHEN BRASGALLA, ARCHITECT
STATE OF FLORIDA
REGISTRATION NO. AR12239
6901 WEST BROWARD BOULEVARD
SUITE 100
PLANTATION, FLORIDA 33317
TELEPHONE 954.614.3801
TELEFAX 954.208.0800
ARCHITECT @ DESIGN23.NET

**CLIENT APPROVAL SET
9-19-16
(NOT FOR CONSTRUCTION)**

Drawn By: RSS	Checked By: STB
Scale: SHOWN	Date: 7-29-16
Project Number 160412	
Sheet: FA - 1	

FIRE ALARM PLAN
SCALE: 1/8" = 1'-0"

